


Construction Plan

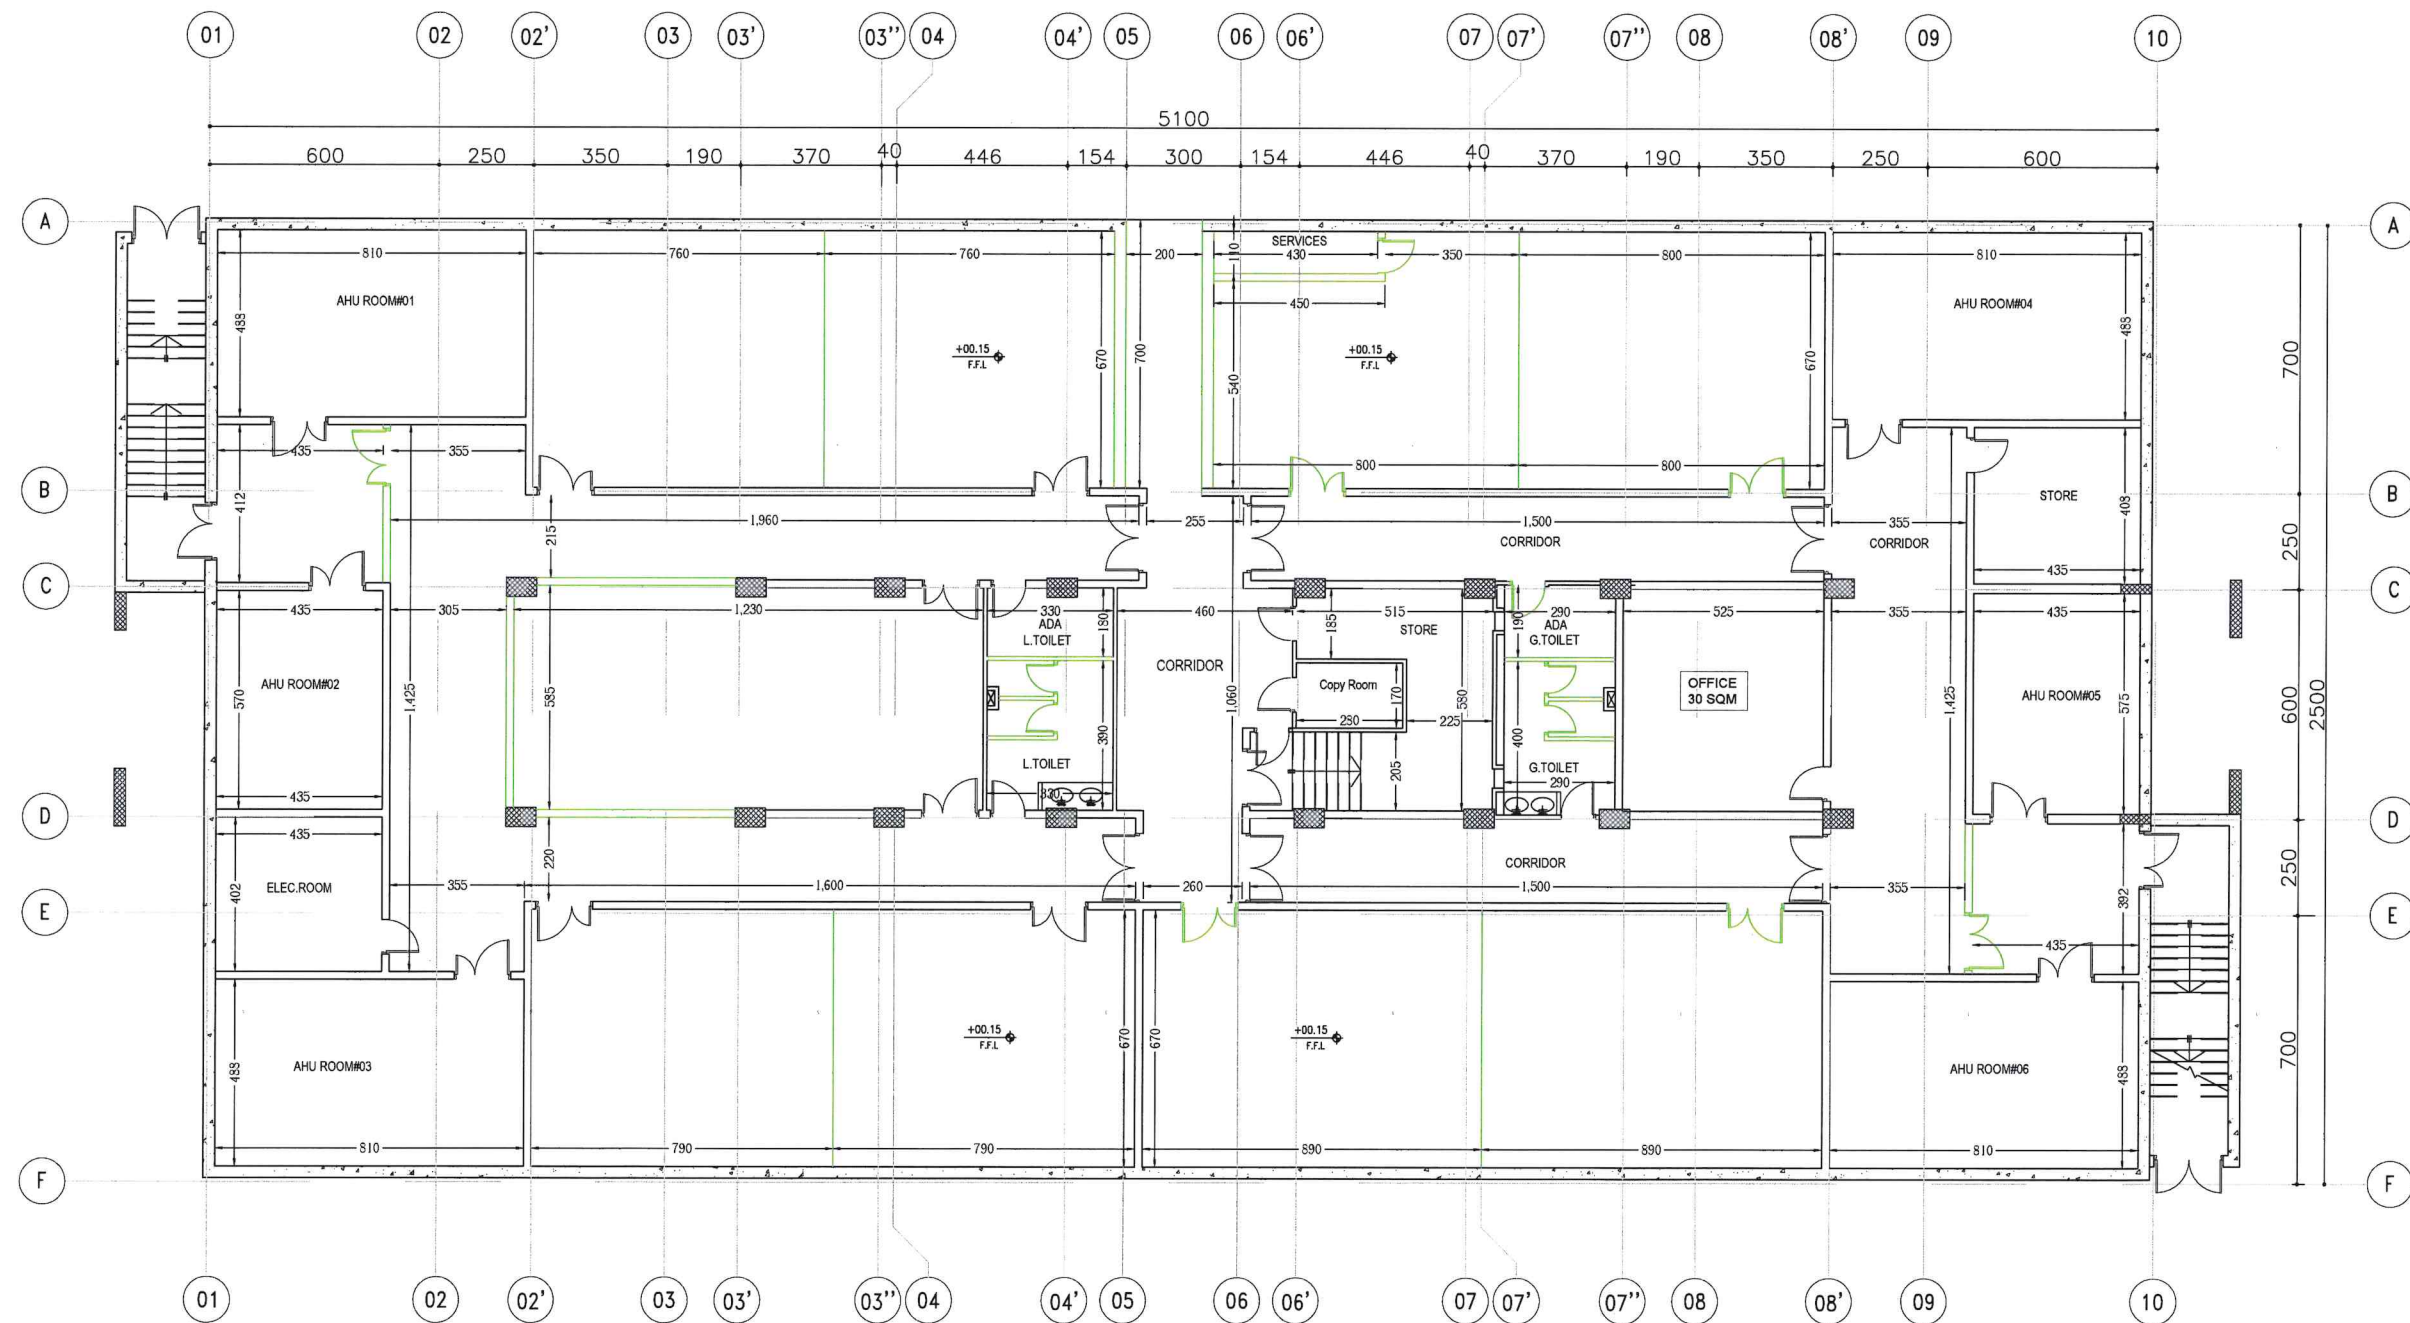


DATE	REVISIONS	DATE	APPROVED

ABDULLAH AL SALEM UNIVERSITY
FACILITIES MANAGEMENT
& ENGINEERING AFFAIRS


PROJECT TITLE:-
KH-11
Class Rooms (C.O.S)

DRAWING TITLE:-
BASEMENT CONSTRUCTION PLAN


CHECKED BY	SERVICES	CIVIL	ARCH.	SCALE
				1:100
APPROVED BY	DRAWN BY	HVAC	ELEC.	DATE
				MAY.2014

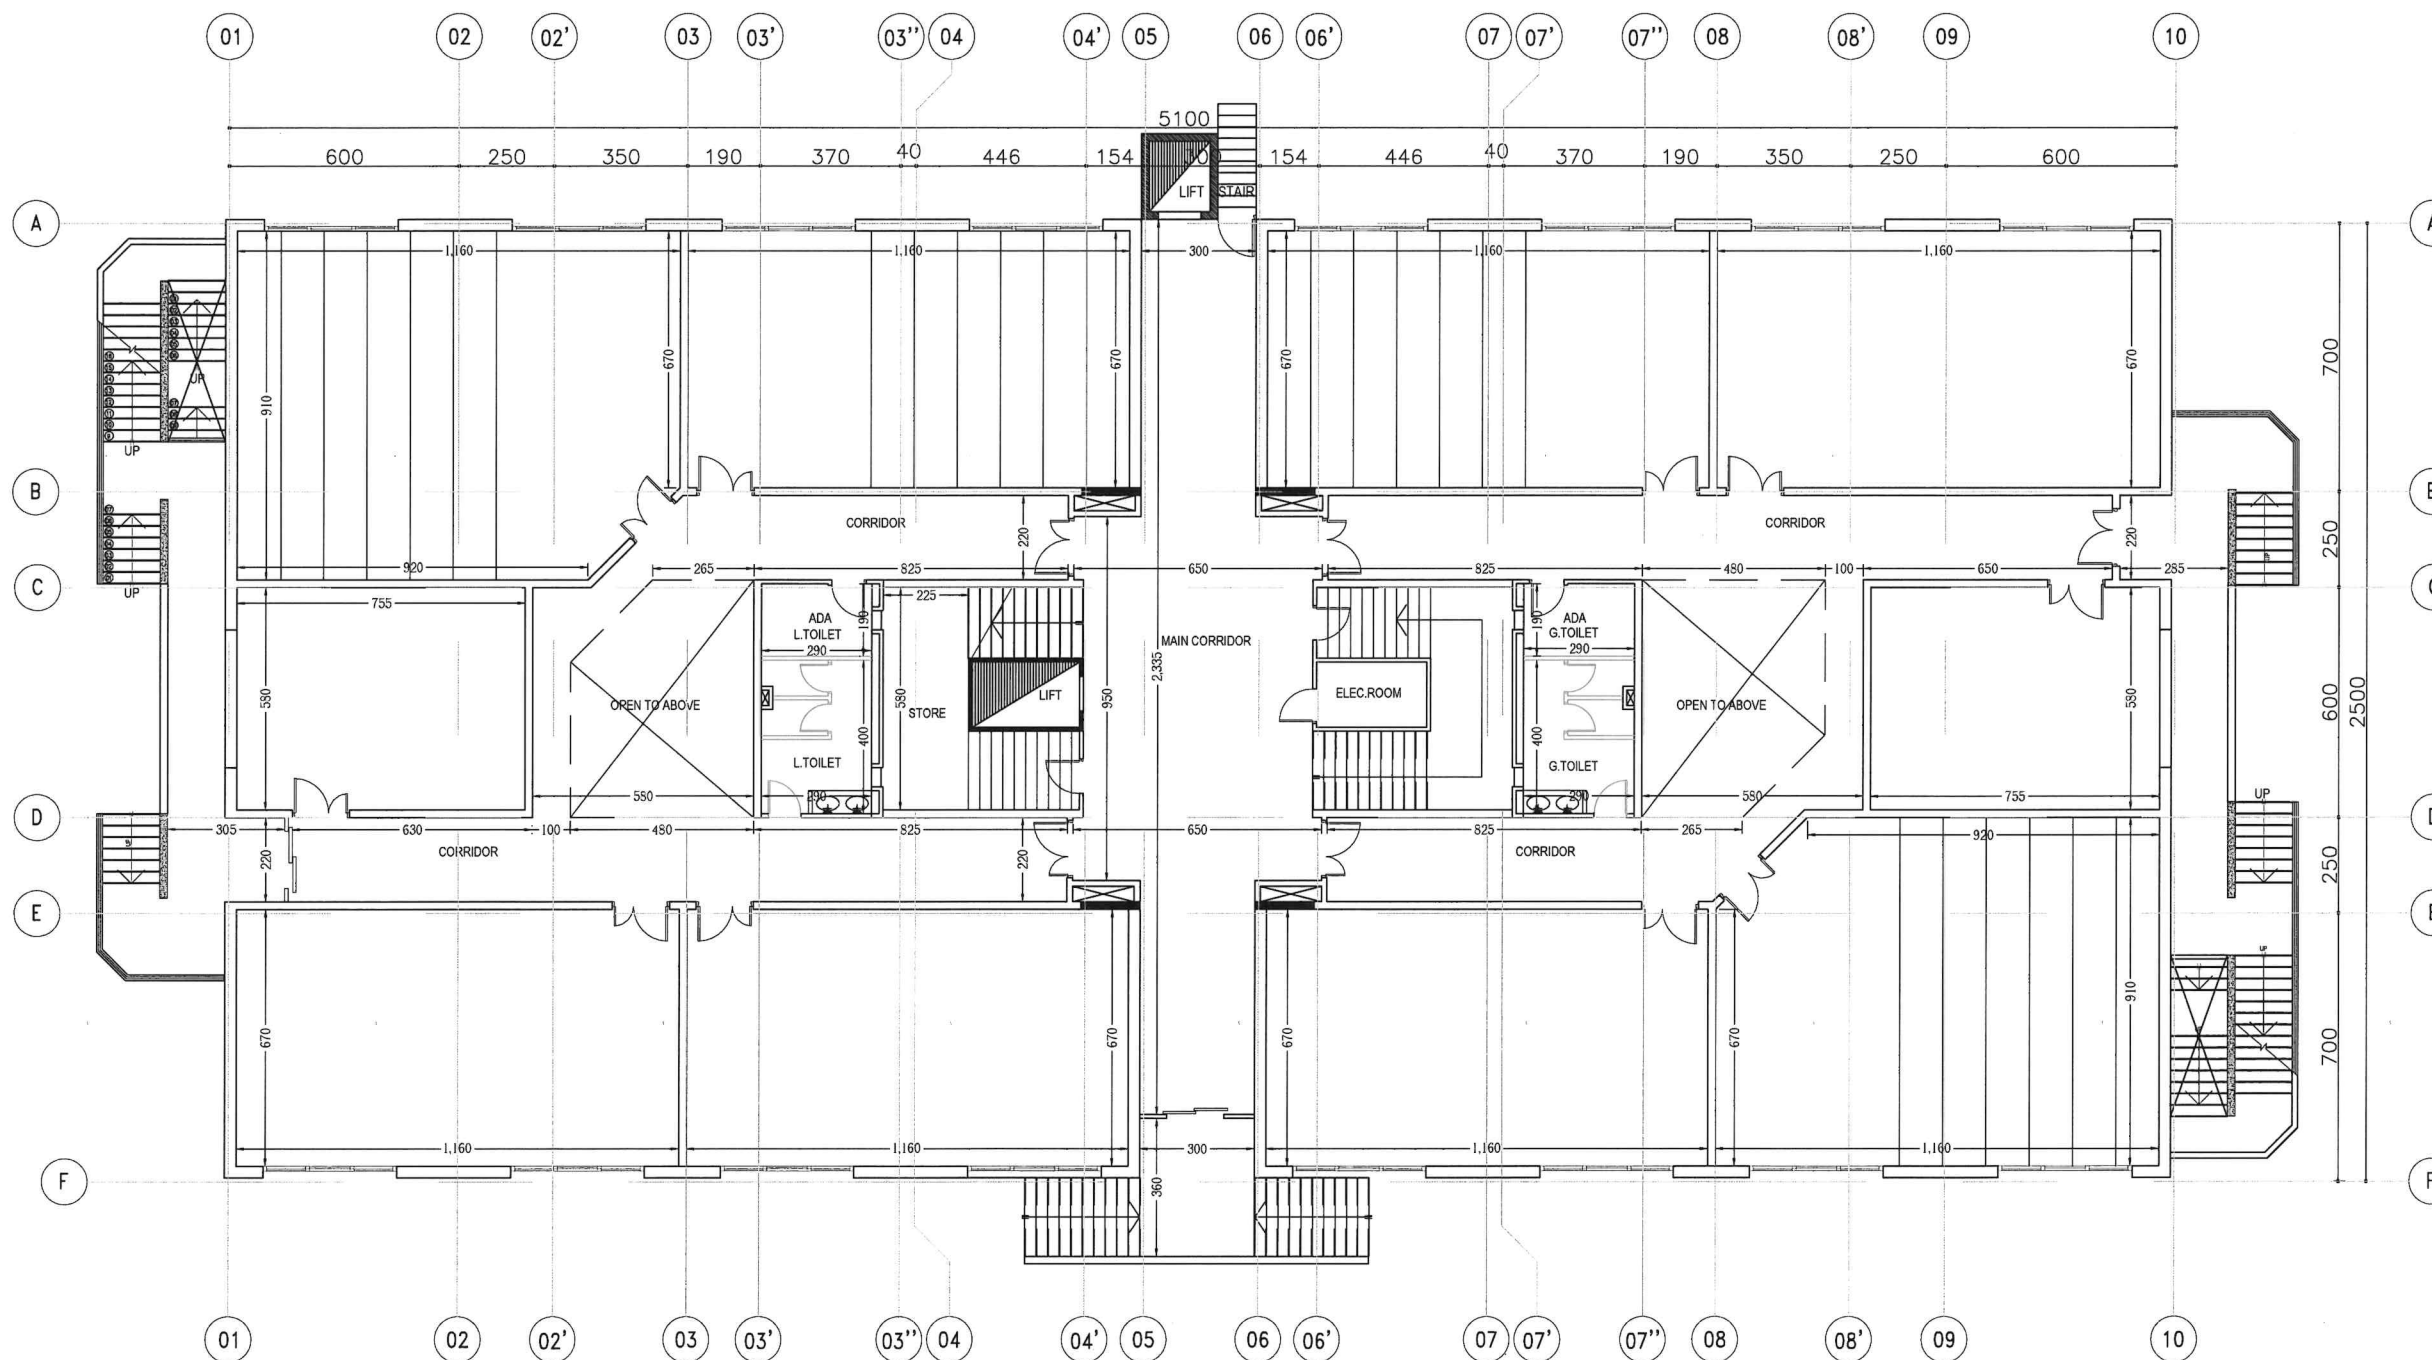

DATE	REVISIONS	DATE	APPROVED
ABDULLAH AL SALEM UNIVERSITY FACILITIES MANAGEMENT & ENGINEERING AFFAIRS			
PROJECT TITLE:- KH-11 Class Rooms (C.O.S)			
DRAWING TITLE:-			DRAWING NO.
GROUND FLOOR CONSTRUCTION PLAN			SCALE
CHECKED BY	SERVICES	CIVIL	ARCH.
APPROVED BY			DATE
			MAY.2014

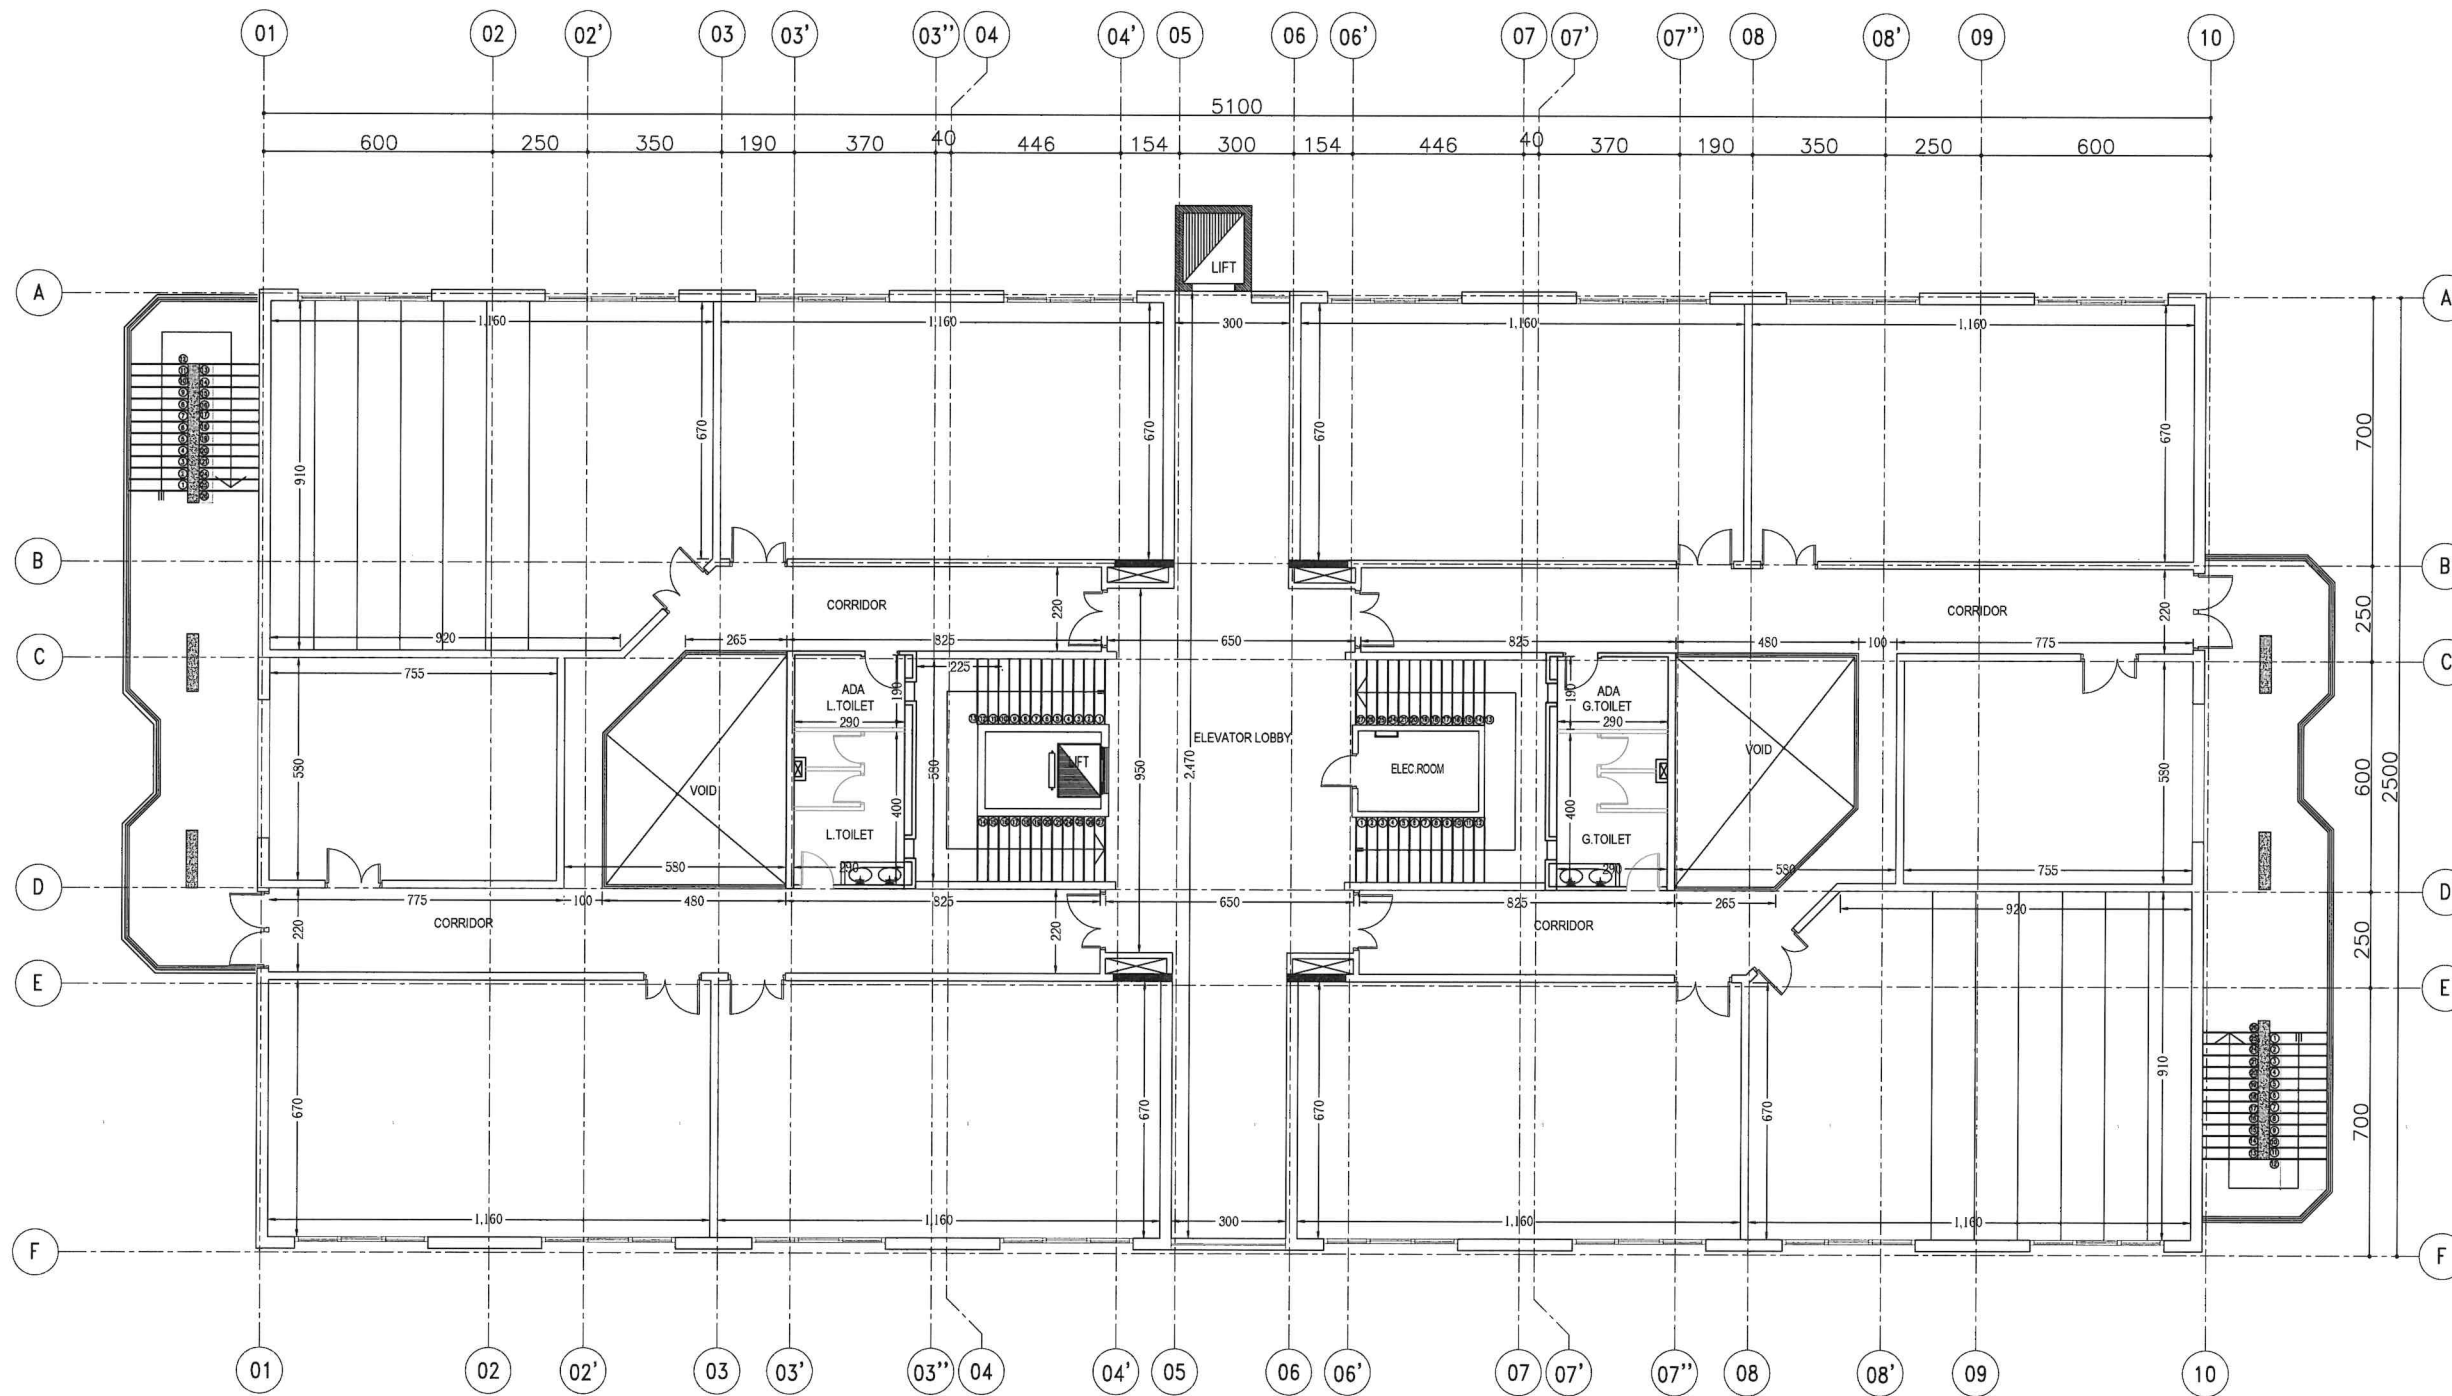



DATE	REVISIONS	DATE	APPROVED
ABDULLAH AL SALEM UNIVERSITY FACILITIES MANAGEMENT & ENGINEERING AFFAIRS			
PROJECT TITLE:- KH-11 Class Rooms (C.O.S)			
DRAWING TITLE:- FIRST FLOOR CONSTRUCTION PLAN			DRAWING NO.
CHECKED BY	SERVICES	CIVIL	ARCH.
APPROVED BY	DRAWN BY	HVAC	ELEC.
			SCALE 1:100
			DATE MAY.2014

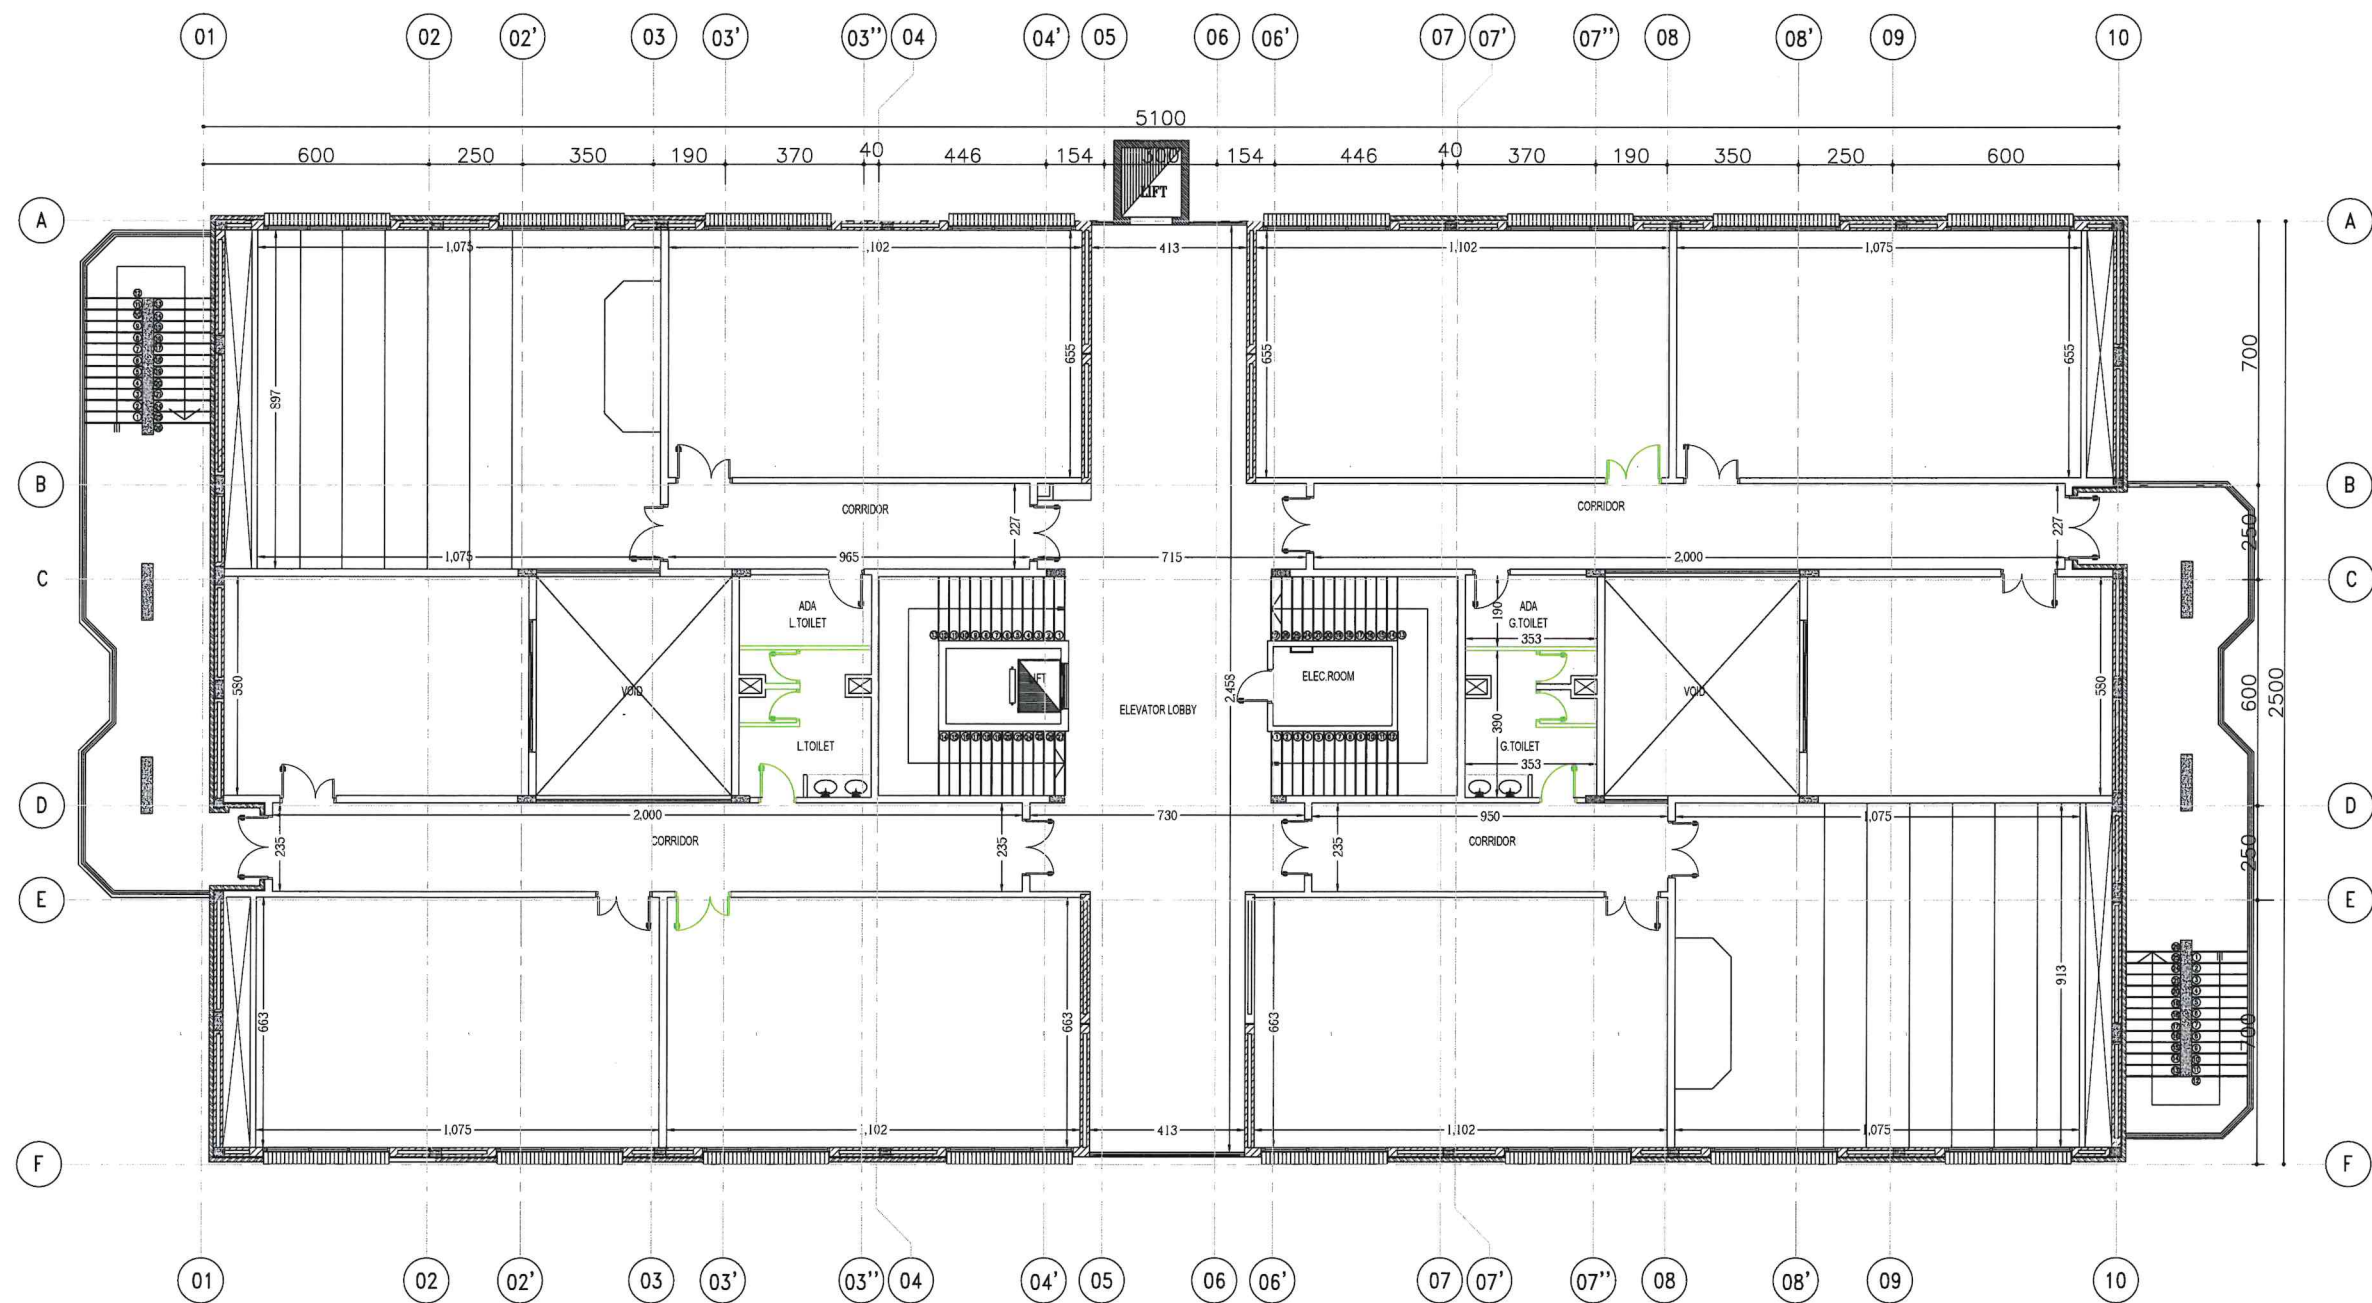

DATE	REVISIONS	DATE	APPROVED
ABDULLAH AL SALEM UNIVERSITY FACILITIES MANAGEMENT & ENGINEERING AFFAIRS			
PROJECT TITLE:- KH-11 Class Rooms (C.O.S)			
DRAWING TITLE:- SECOND FLOOR CONSTRUCTION PLAN			DRAWING NO.
CHECKED BY	SERVICES	CIVIL	ARCH.
APPROVED BY	DRAWN BY	HVAC	ELEC.
SCALE 1:100			DATE MAY.2014

Demolition Plan

ORIENTATION

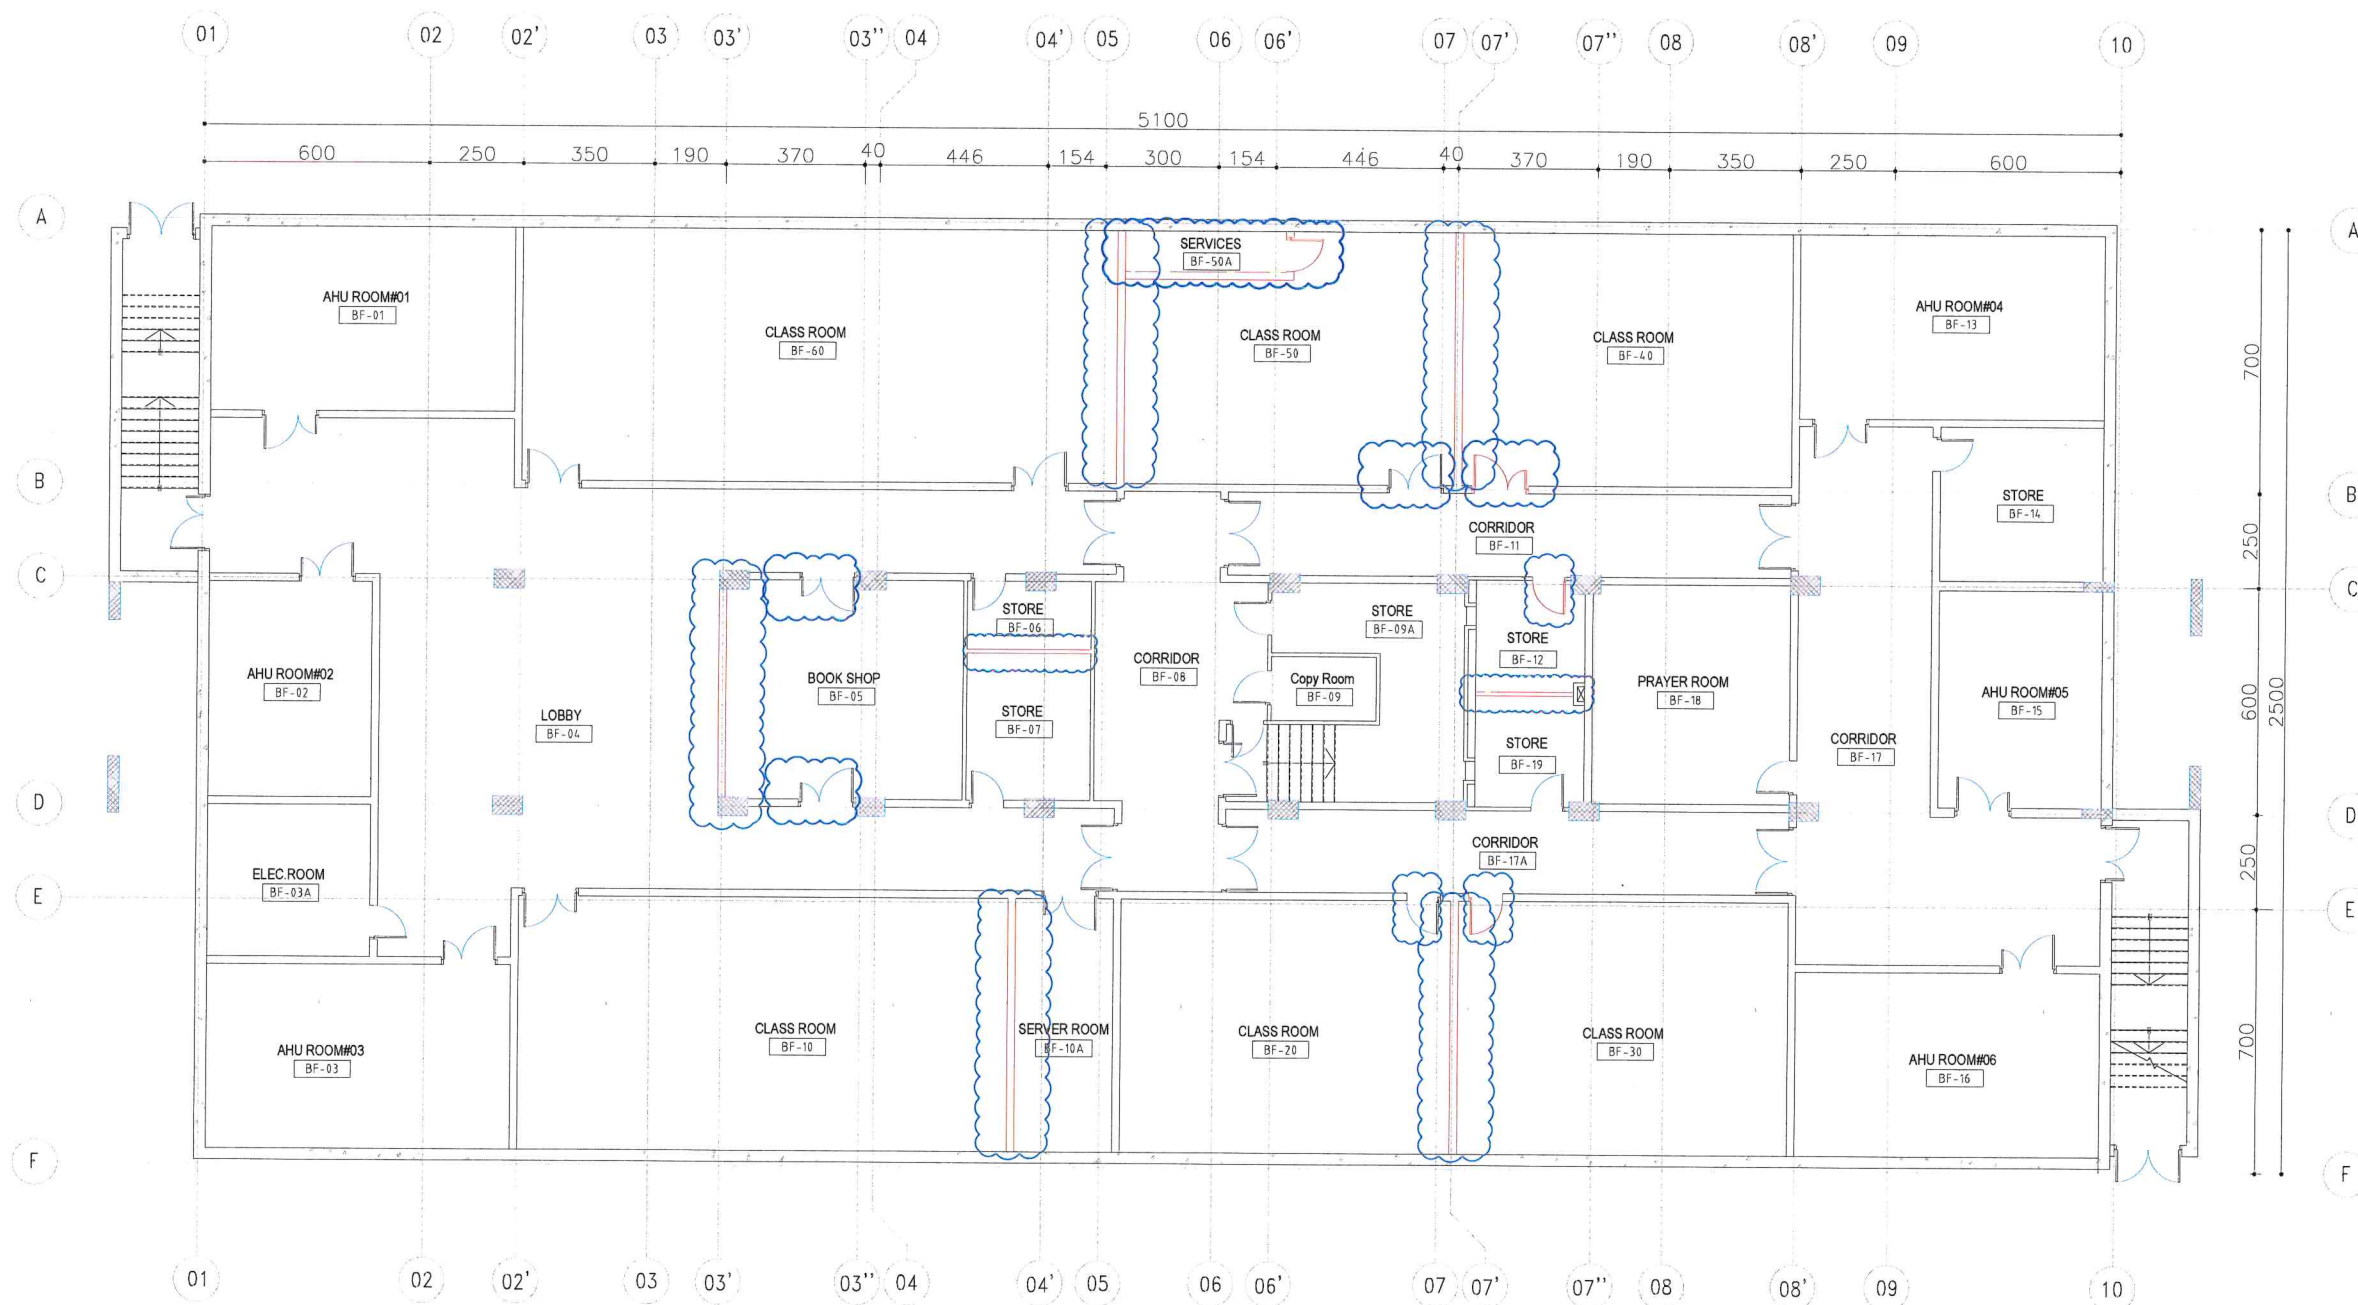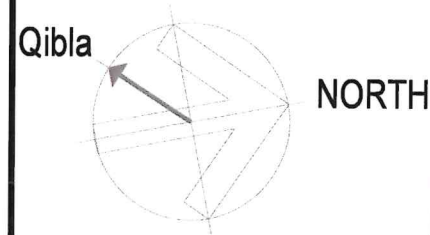

DATE	REVISIONS	DATE	APPROVED

ABDULLAH AL SALEM UNIVERSITY
FACILITIES MANAGEMENT
& ENGINEERING AFFAIRS



PROJECT TITLE:-
KH-11
Class Rooms (C.O.S)

DRAWING TITLE:-
BASEMENT FLOOR DEMOLITION PLAN

CHECKED BY	SERVICES	CIVIL	ARCH.	SCALE
				1:100
APPROVED BY	DRAWN BY	HVAC	ELEC.	DATE



ORIENTATION

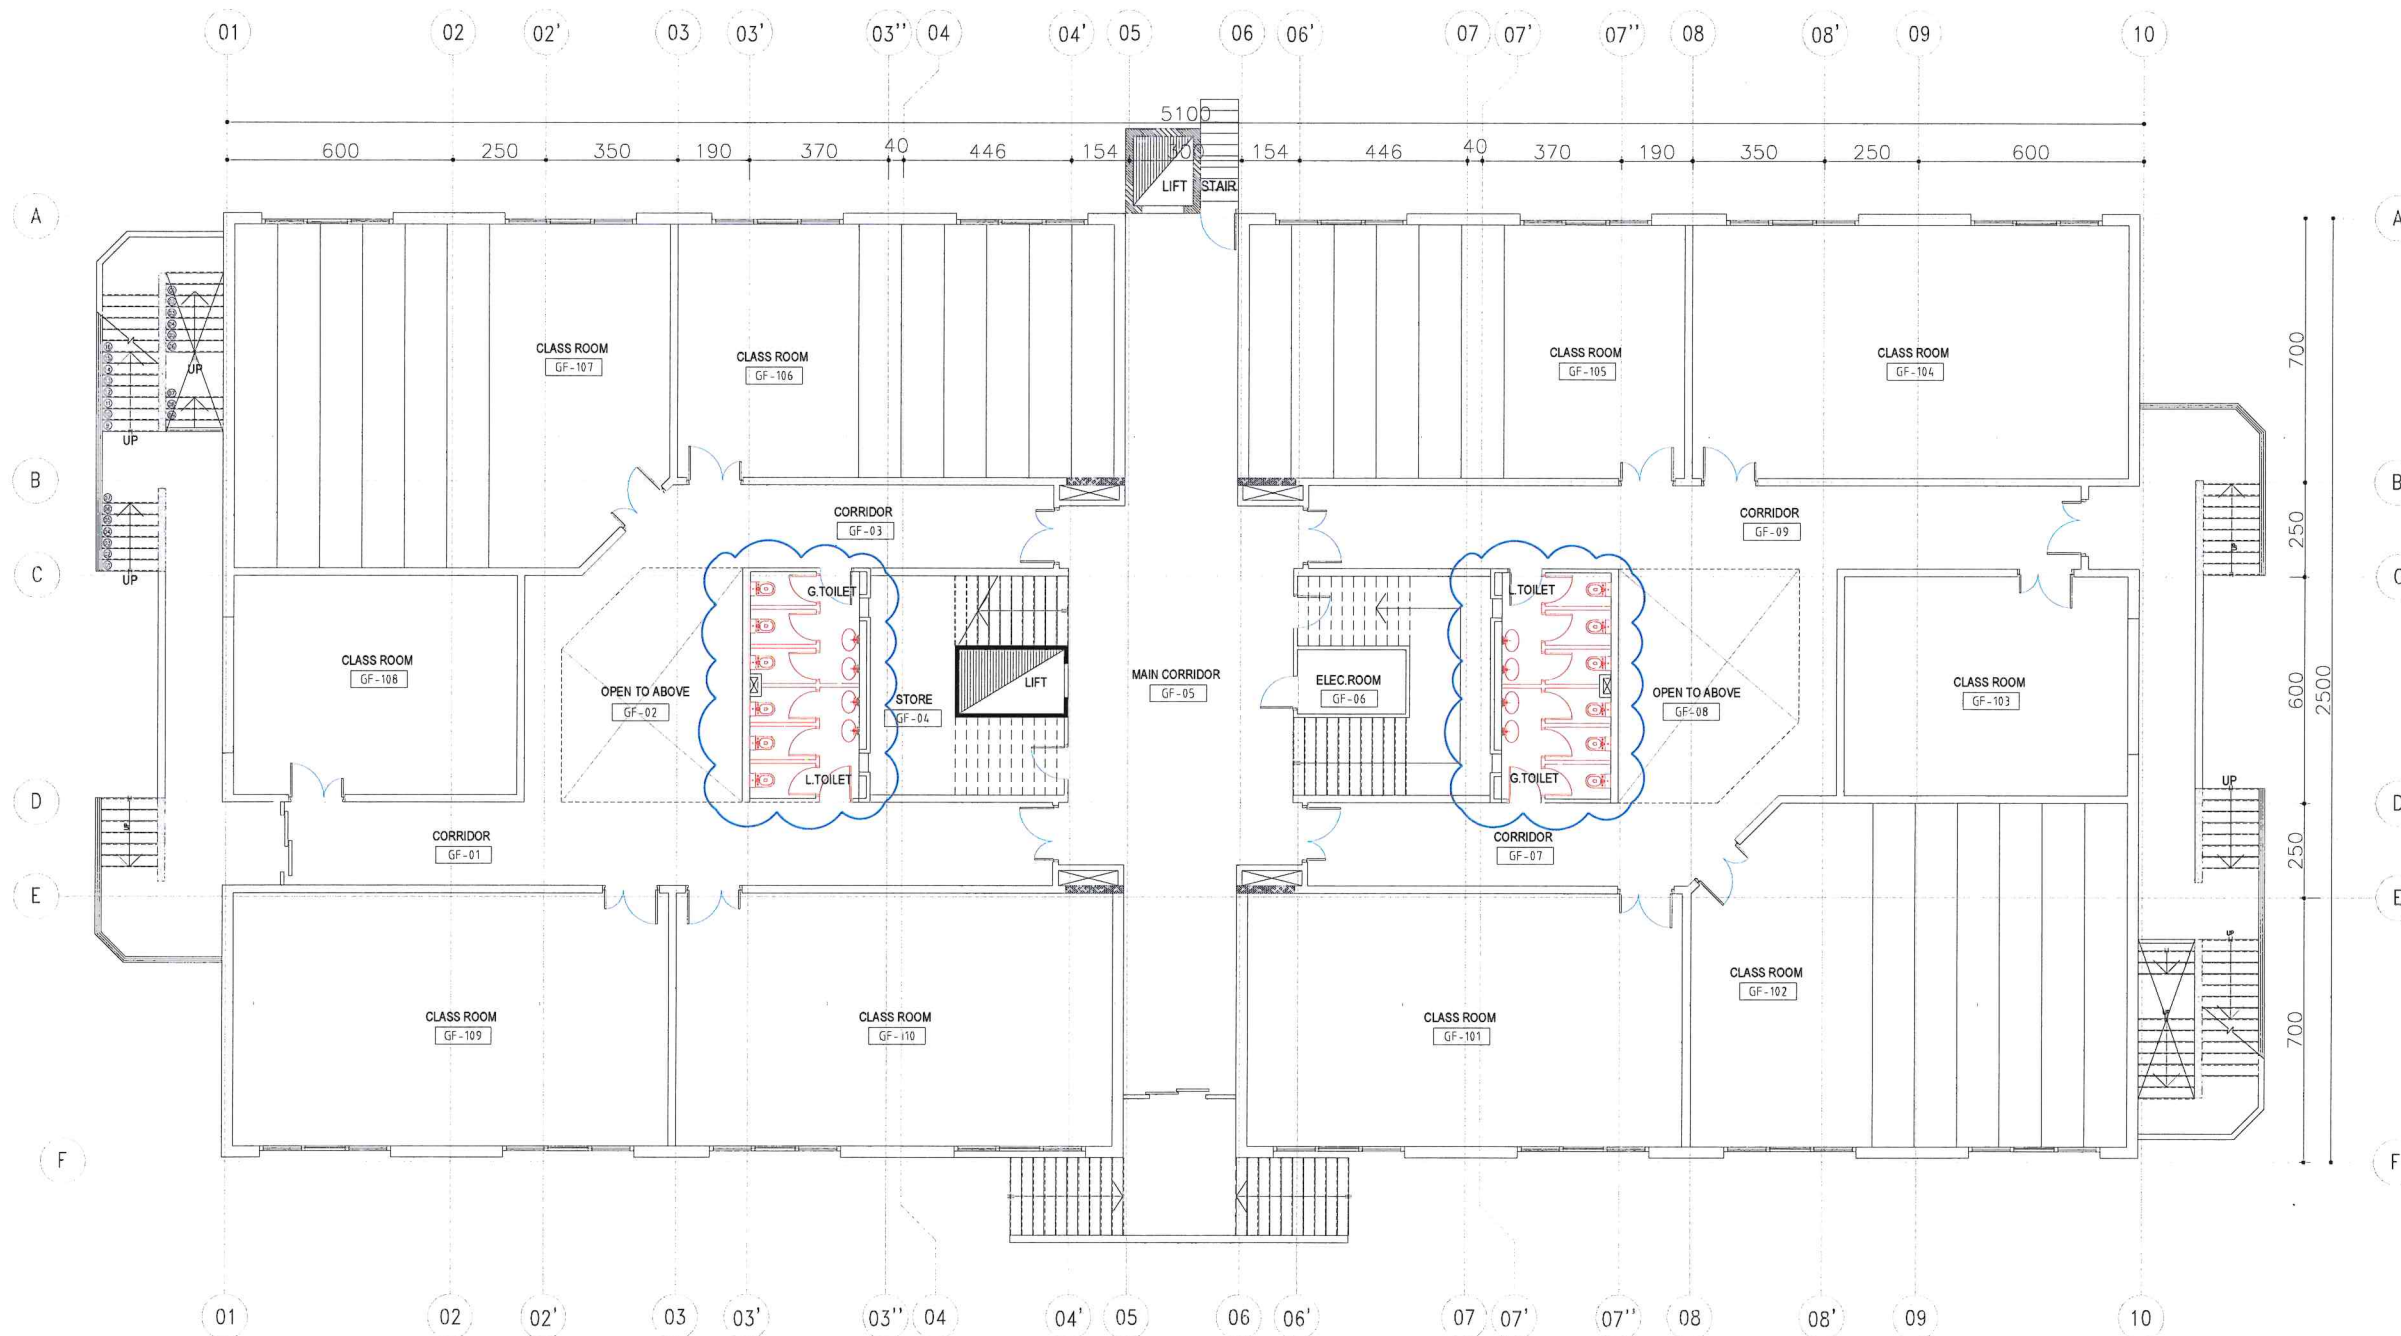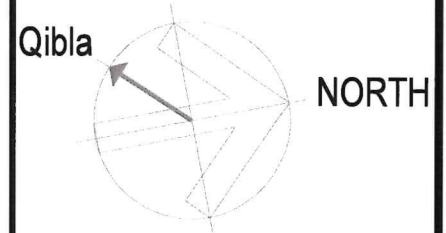

DATE	REVISIONS	DATE	APPROVED

ABDULLAH AL SALEM UNIVERSITY
FACILITIES MANAGEMENT
& ENGINEERING AFFAIRS

PROJECT TITLE:-


KH-11
Class Rooms (C.O.S)

DRAWING TITLE:-

GROUND FLOOR DEMOLITION PLAN



DRAWING NO.

CHECKED BY	SERVICES	CIVIL	ARCH.	SCALE
				1:100
APPROVED BY	DRAWN BY	HVAC	ELEC.	DATE

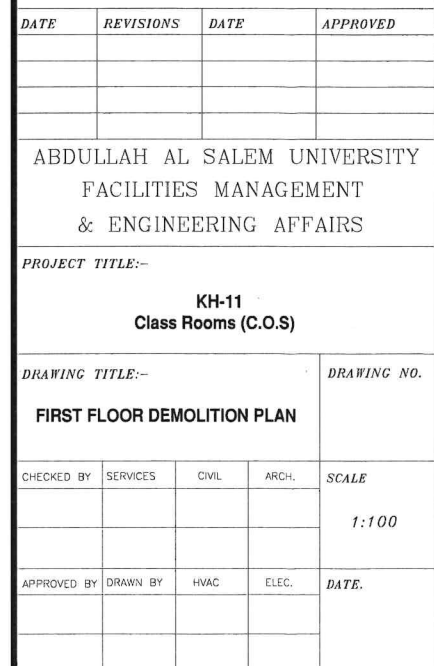



ORIENTATION

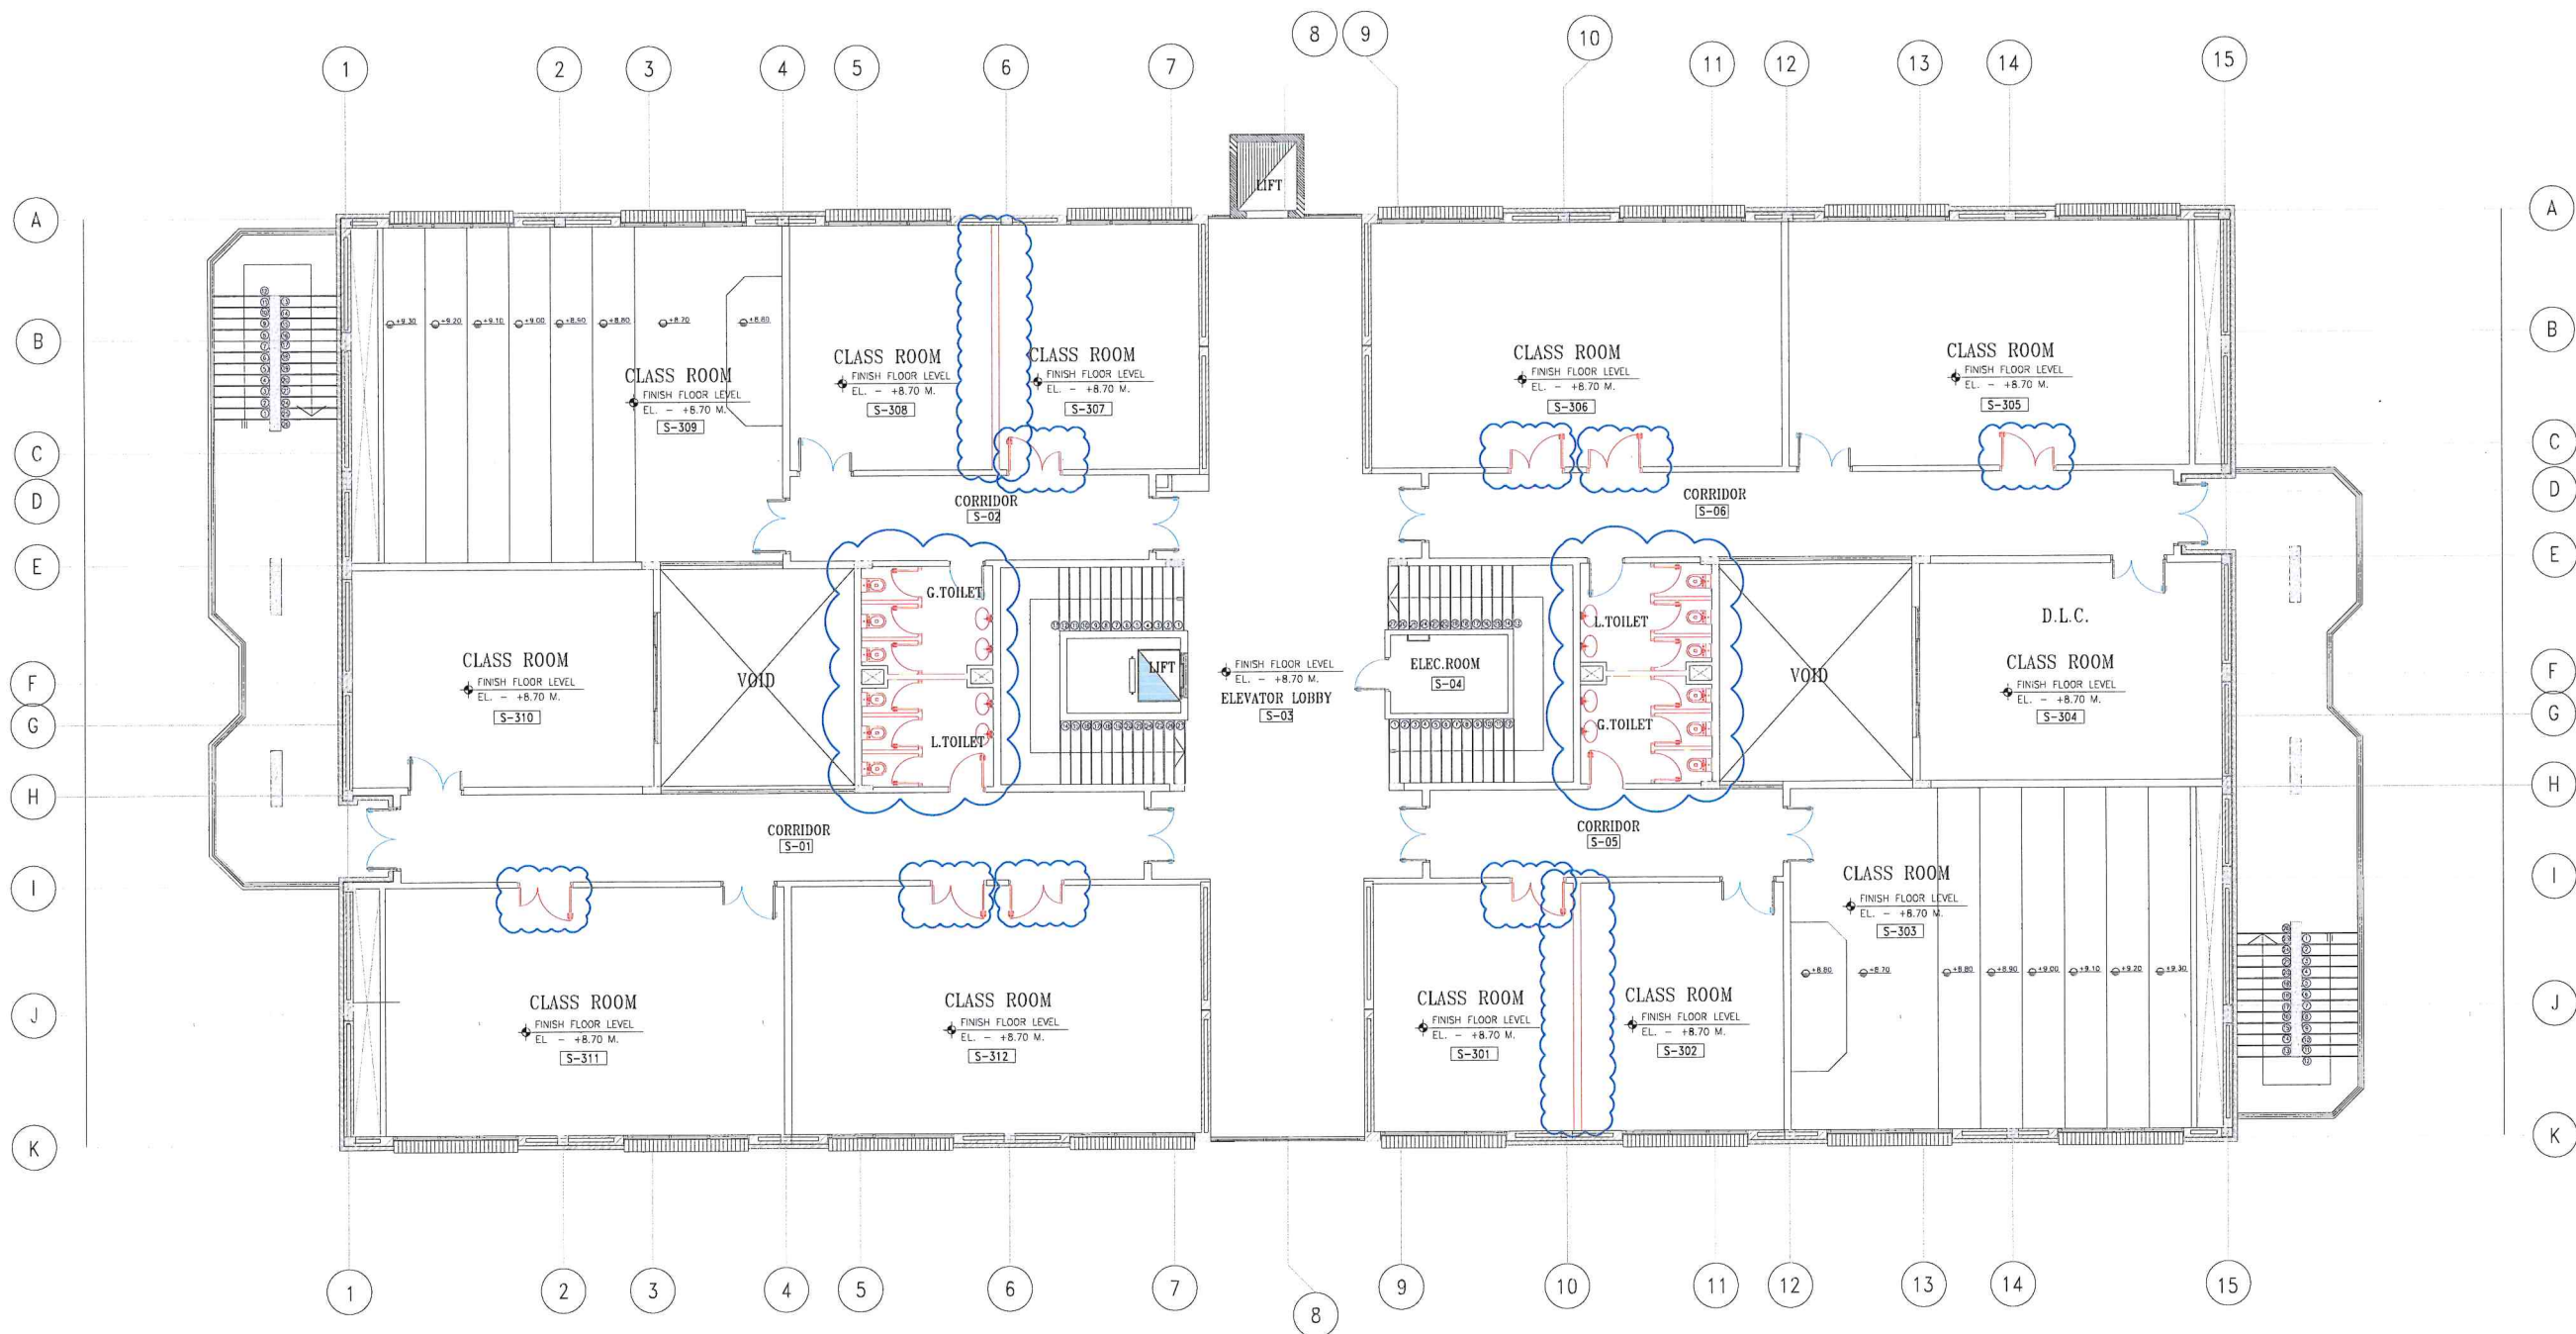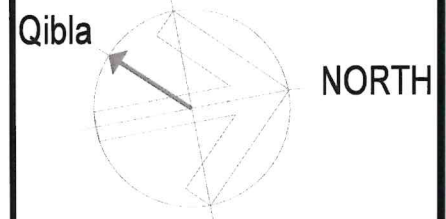

DATE	REVISIONS	DATE	APPROVED

ABDULLAH AL SALEM UNIVERSITY
FACILITIES MANAGEMENT
& ENGINEERING AFFAIRS

PROJECT TITLE:-

KH-11
Class Rooms (C.O.S)


DRAWING TITLE:-

SECOND FLOOR DEMOLITION PLAN

DRAWING NO.

CHECKED BY	SERVICES	CIVIL	ARCH.	SCALE
				1:100
APPROVED BY	DRAWN BY	HVAC	ELEC.	DATE
				MAY.2014

Electric Plan

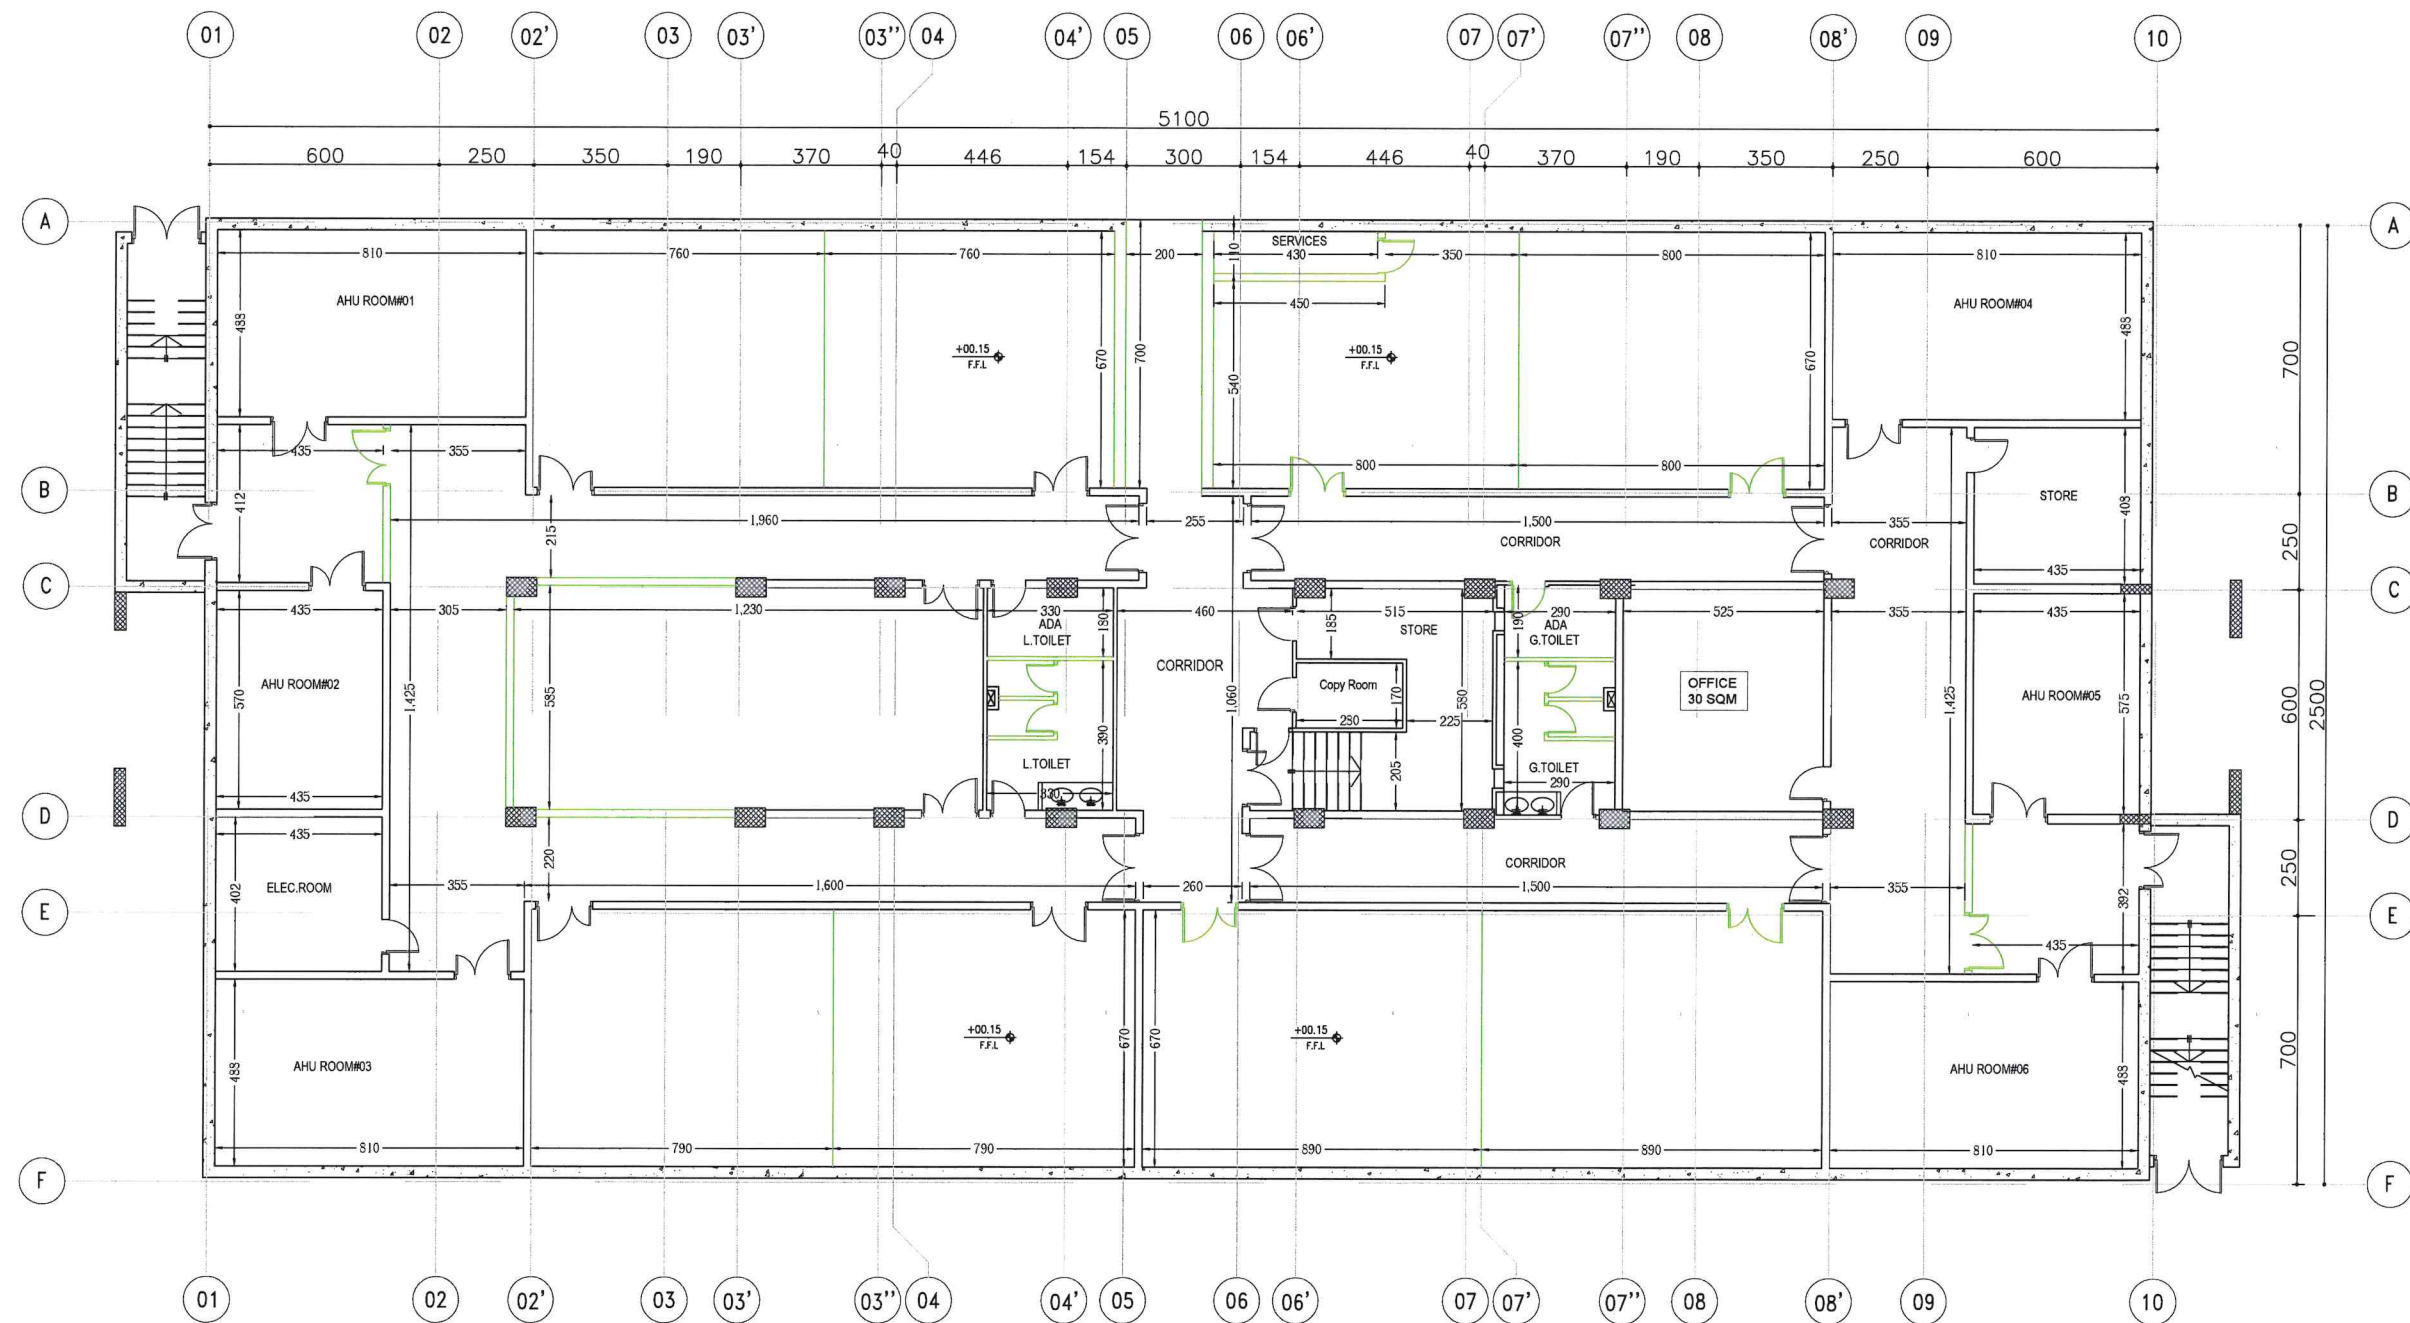

DATE	REVISIONS	DATE	APPROVED

ABDULLAH AL SALEM UNIVERSITY
FACILITIES MANAGEMENT
& ENGINEERING AFFAIRS

PROJECT TITLE:-
KH-11
Class Rooms (C.O.S)

DRAWING TITLE:-
BASEMENT CONSTRUCTION PLAN


DRAWING NO.

CHECKED BY SERVICES CIVIL ARCH. SCALE

1:100

APPROVED BY DRAWN BY HVAC ELEC. DATE

MAY.2014

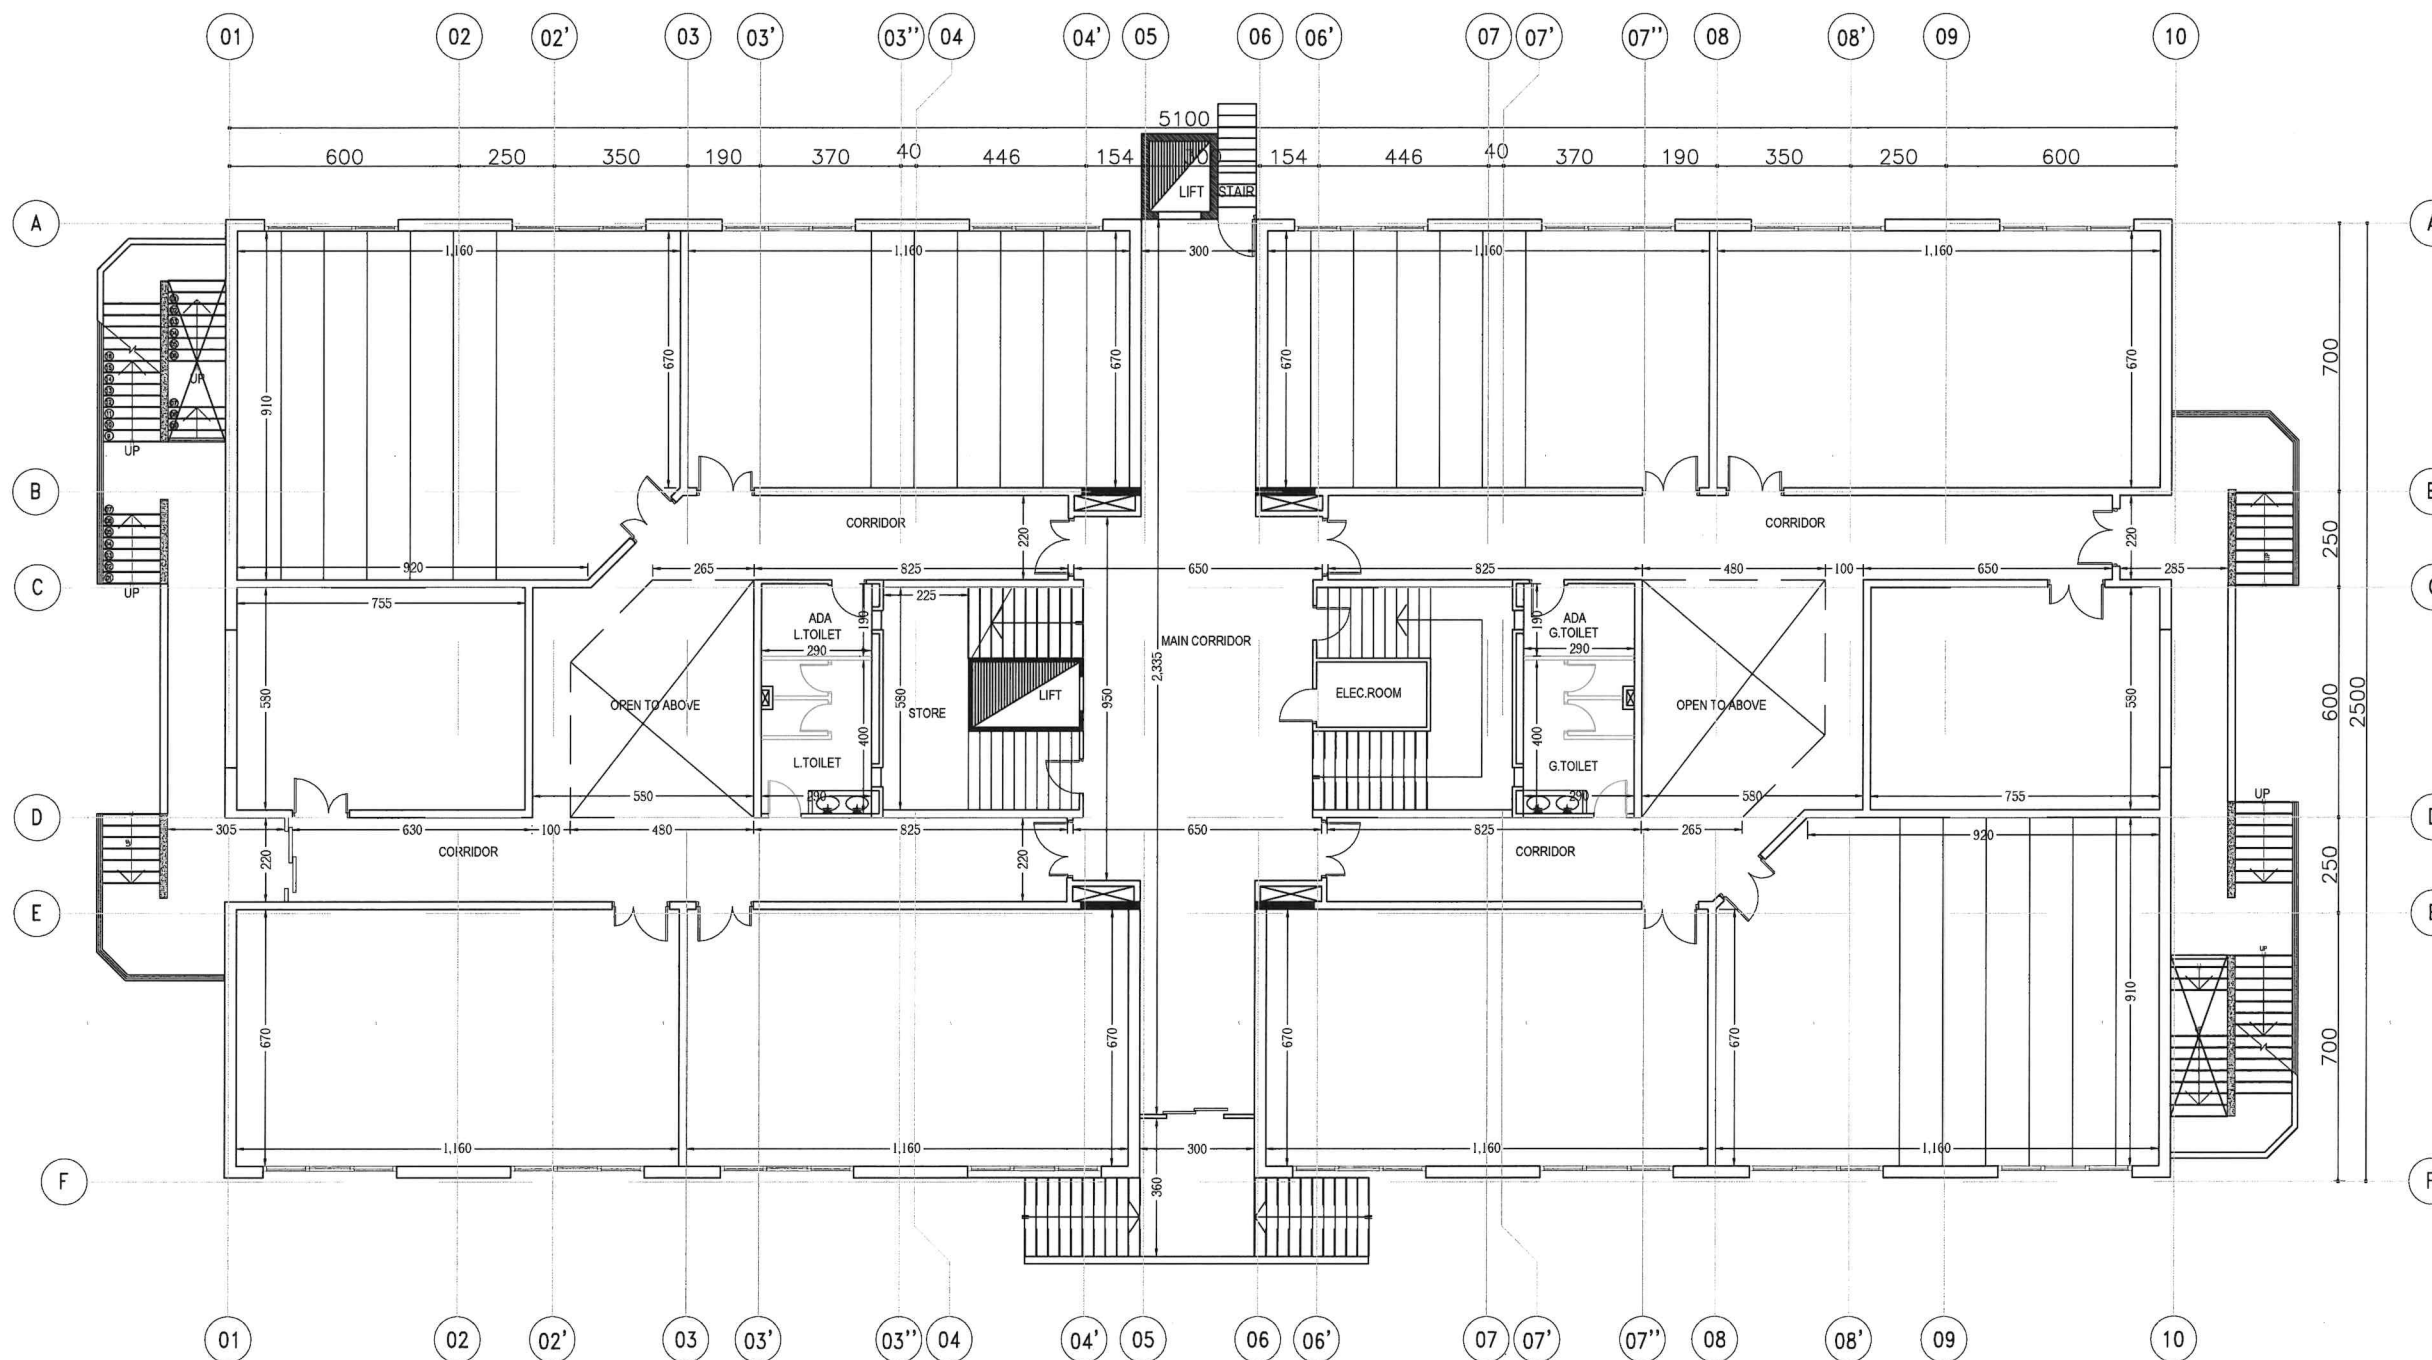

DATE	REVISIONS	DATE	APPROVED

ABDULLAH AL SALEM UNIVERSITY
FACILITIES MANAGEMENT
& ENGINEERING AFFAIRS


PROJECT TITLE:-
KH-11
Class Rooms (C.O.S)

DRAWING TITLE:-
GROUND FLOOR CONSTRUCTION PLAN


DRAWING NO.

CHECKED BY	SERVICES	CIVIL	ARCH.	SCALE
				1:100

APPROVED BY	DRAWN BY	HVAC	ELEC.	DATE
				MAY.2014

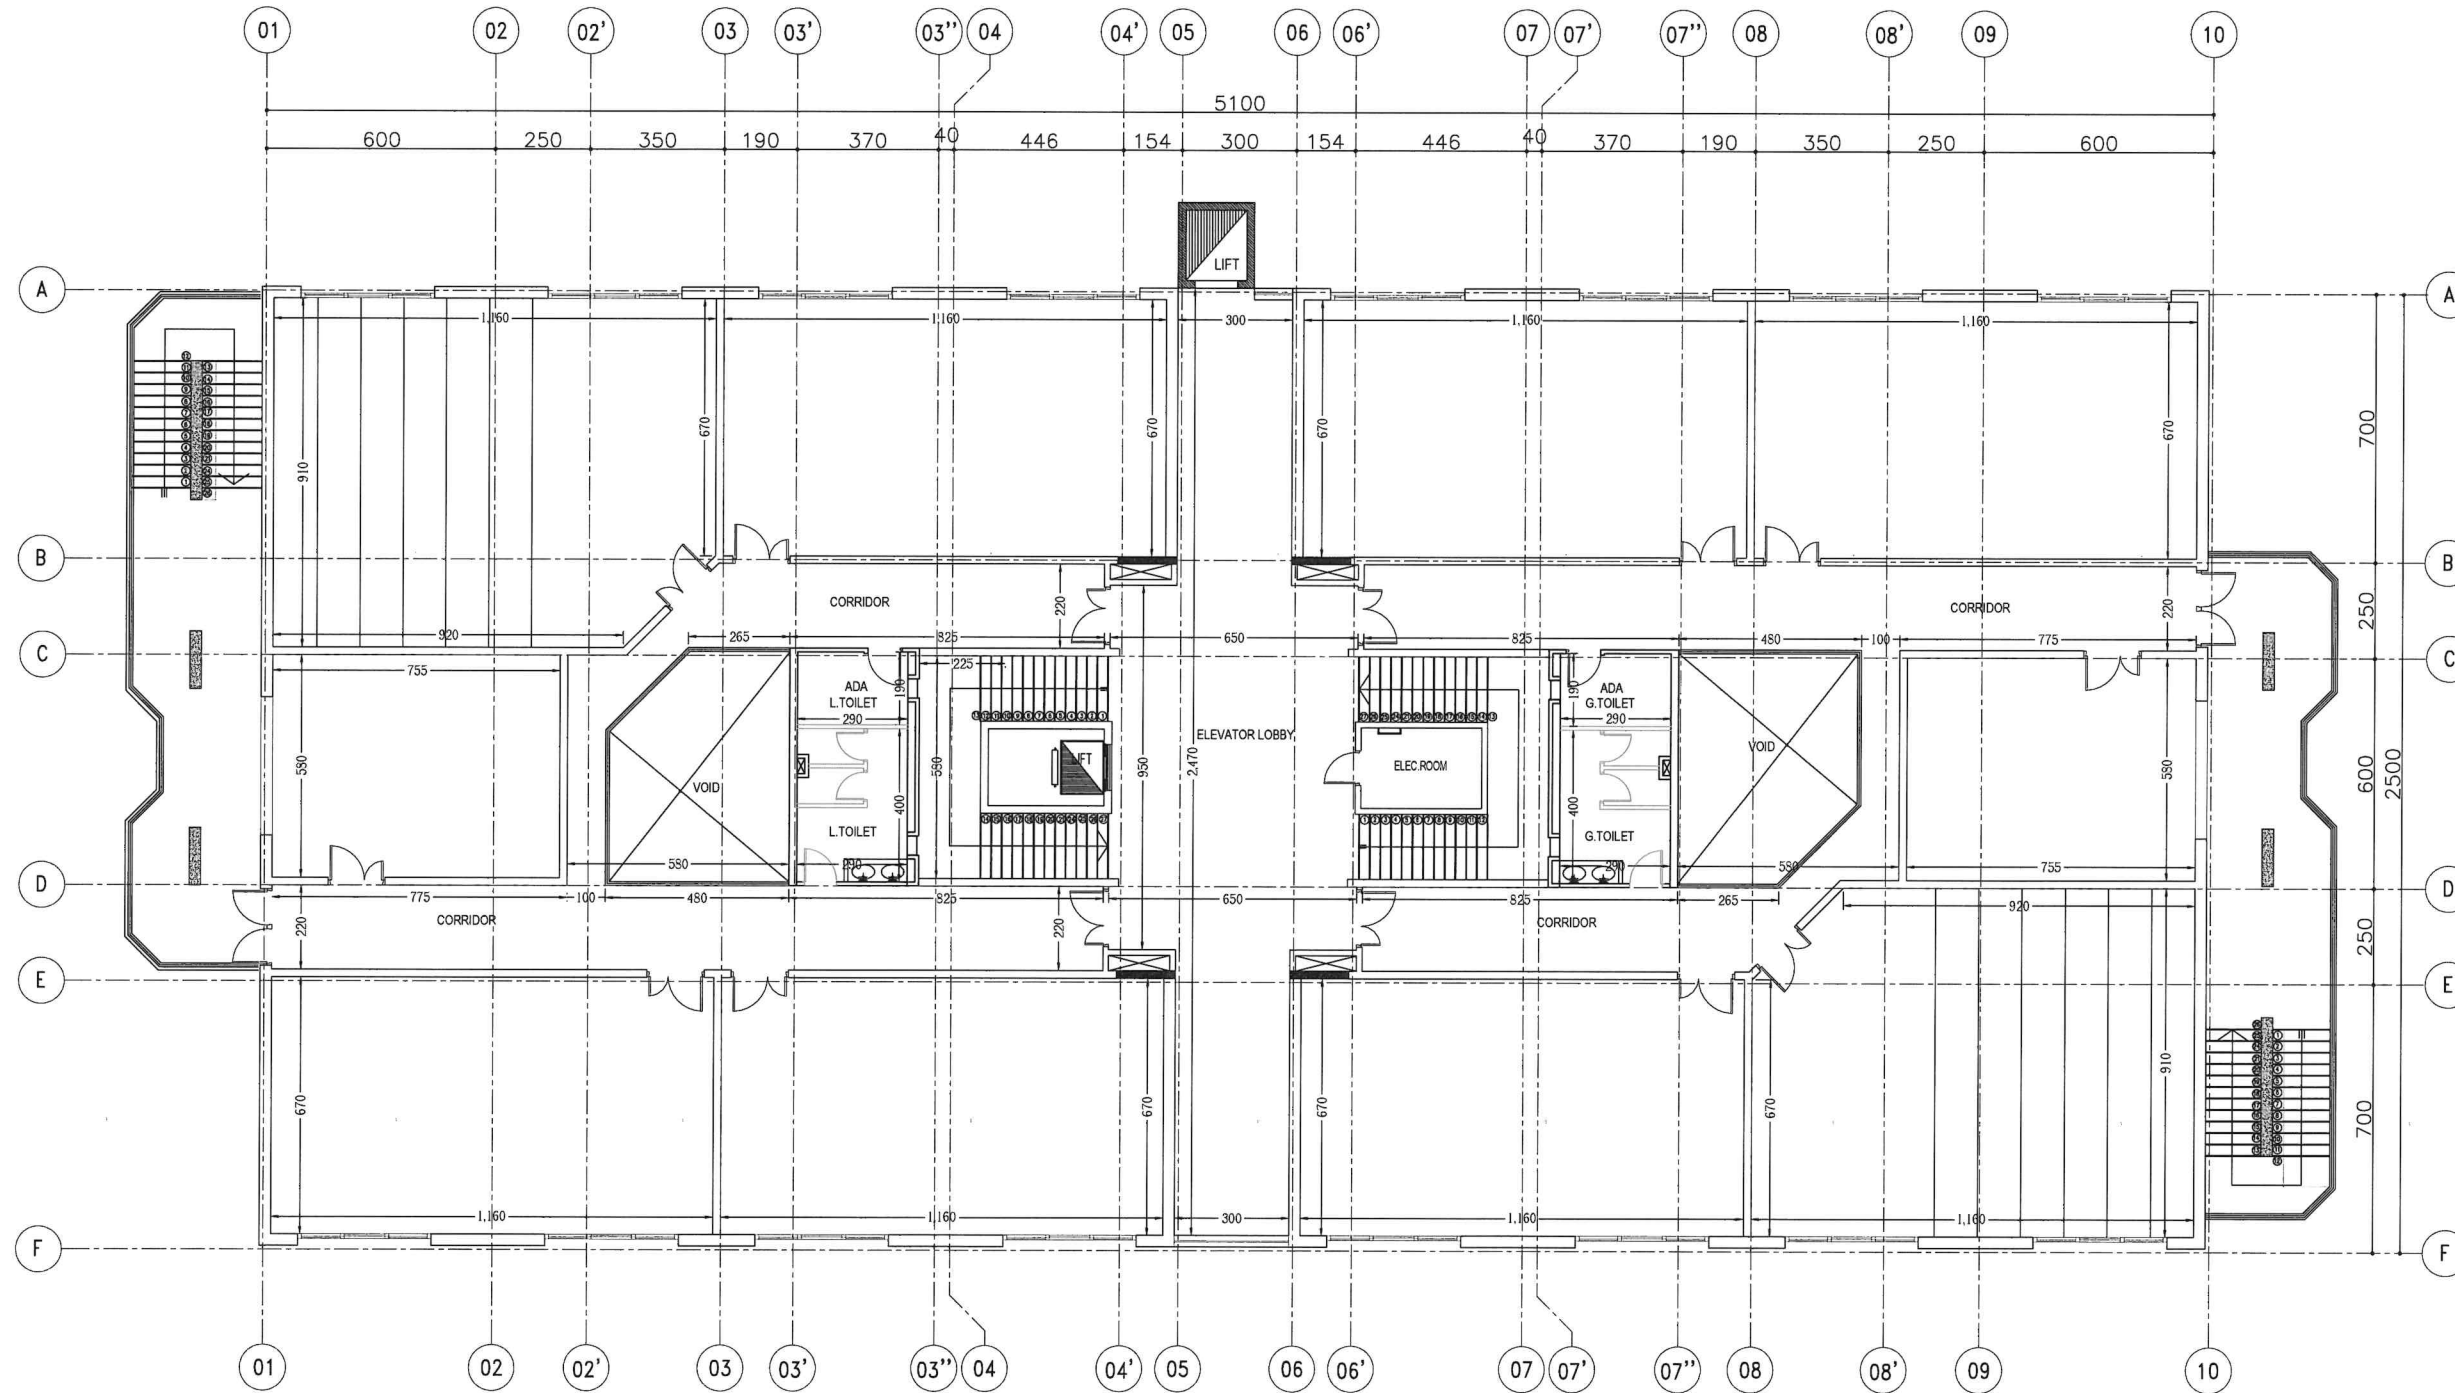


DATE	REVISIONS	DATE	APPROVED
ABDULLAH AL SALEM UNIVERSITY FACILITIES MANAGEMENT & ENGINEERING AFFAIRS			
PROJECT TITLE:- KH-11 Class Rooms (C.O.S)			
DRAWING TITLE:- FIRST FLOOR CONSTRUCTION PLAN			DRAWING NO.
CHECKED BY	SERVICES	CIVIL	ARCH.
APPROVED BY	DRAWN BY	HVAC	ELEC.
			SCALE 1:100
			DATE MAY.2014

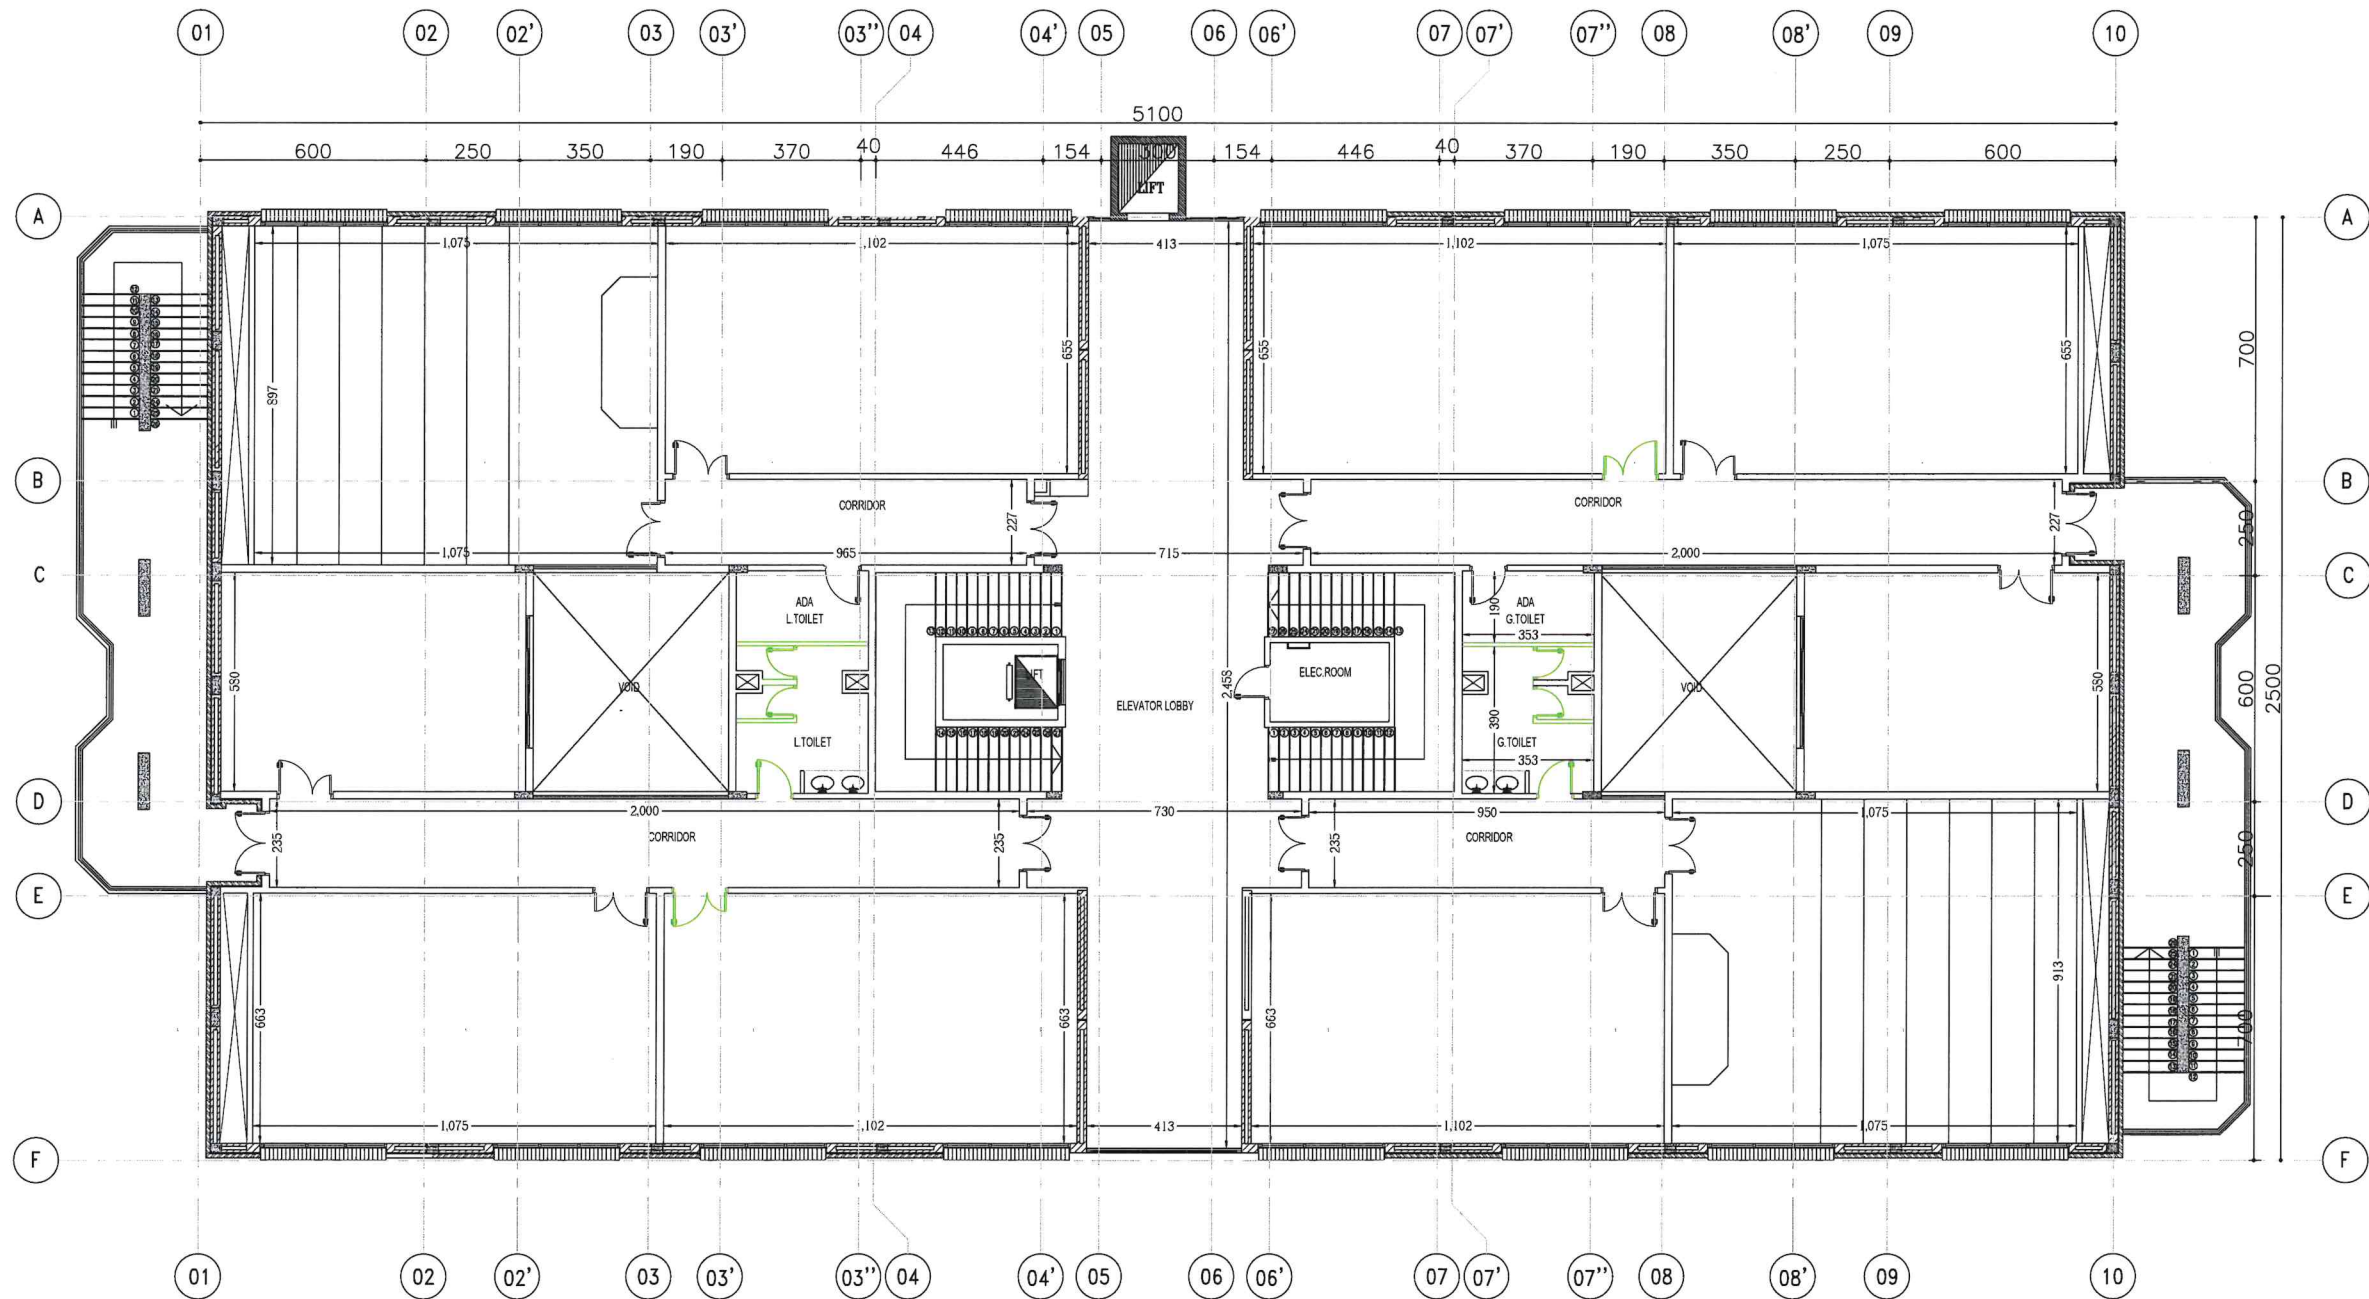

DATE	REVISIONS	DATE	APPROVED
ABDULLAH AL SALEM UNIVERSITY FACILITIES MANAGEMENT & ENGINEERING AFFAIRS			
PROJECT TITLE:- KH-11 Class Rooms (C.O.S)			
DRAWING TITLE:- SECOND FLOOR CONSTRUCTION PLAN			DRAWING NO.
CHECKED BY	SERVICES	CIVIL	ARCH.
APPROVED BY	DRAWN BY	HVAC	ELEC.
SCALE 1:100			DATE MAY.2014

Flooring Pattern

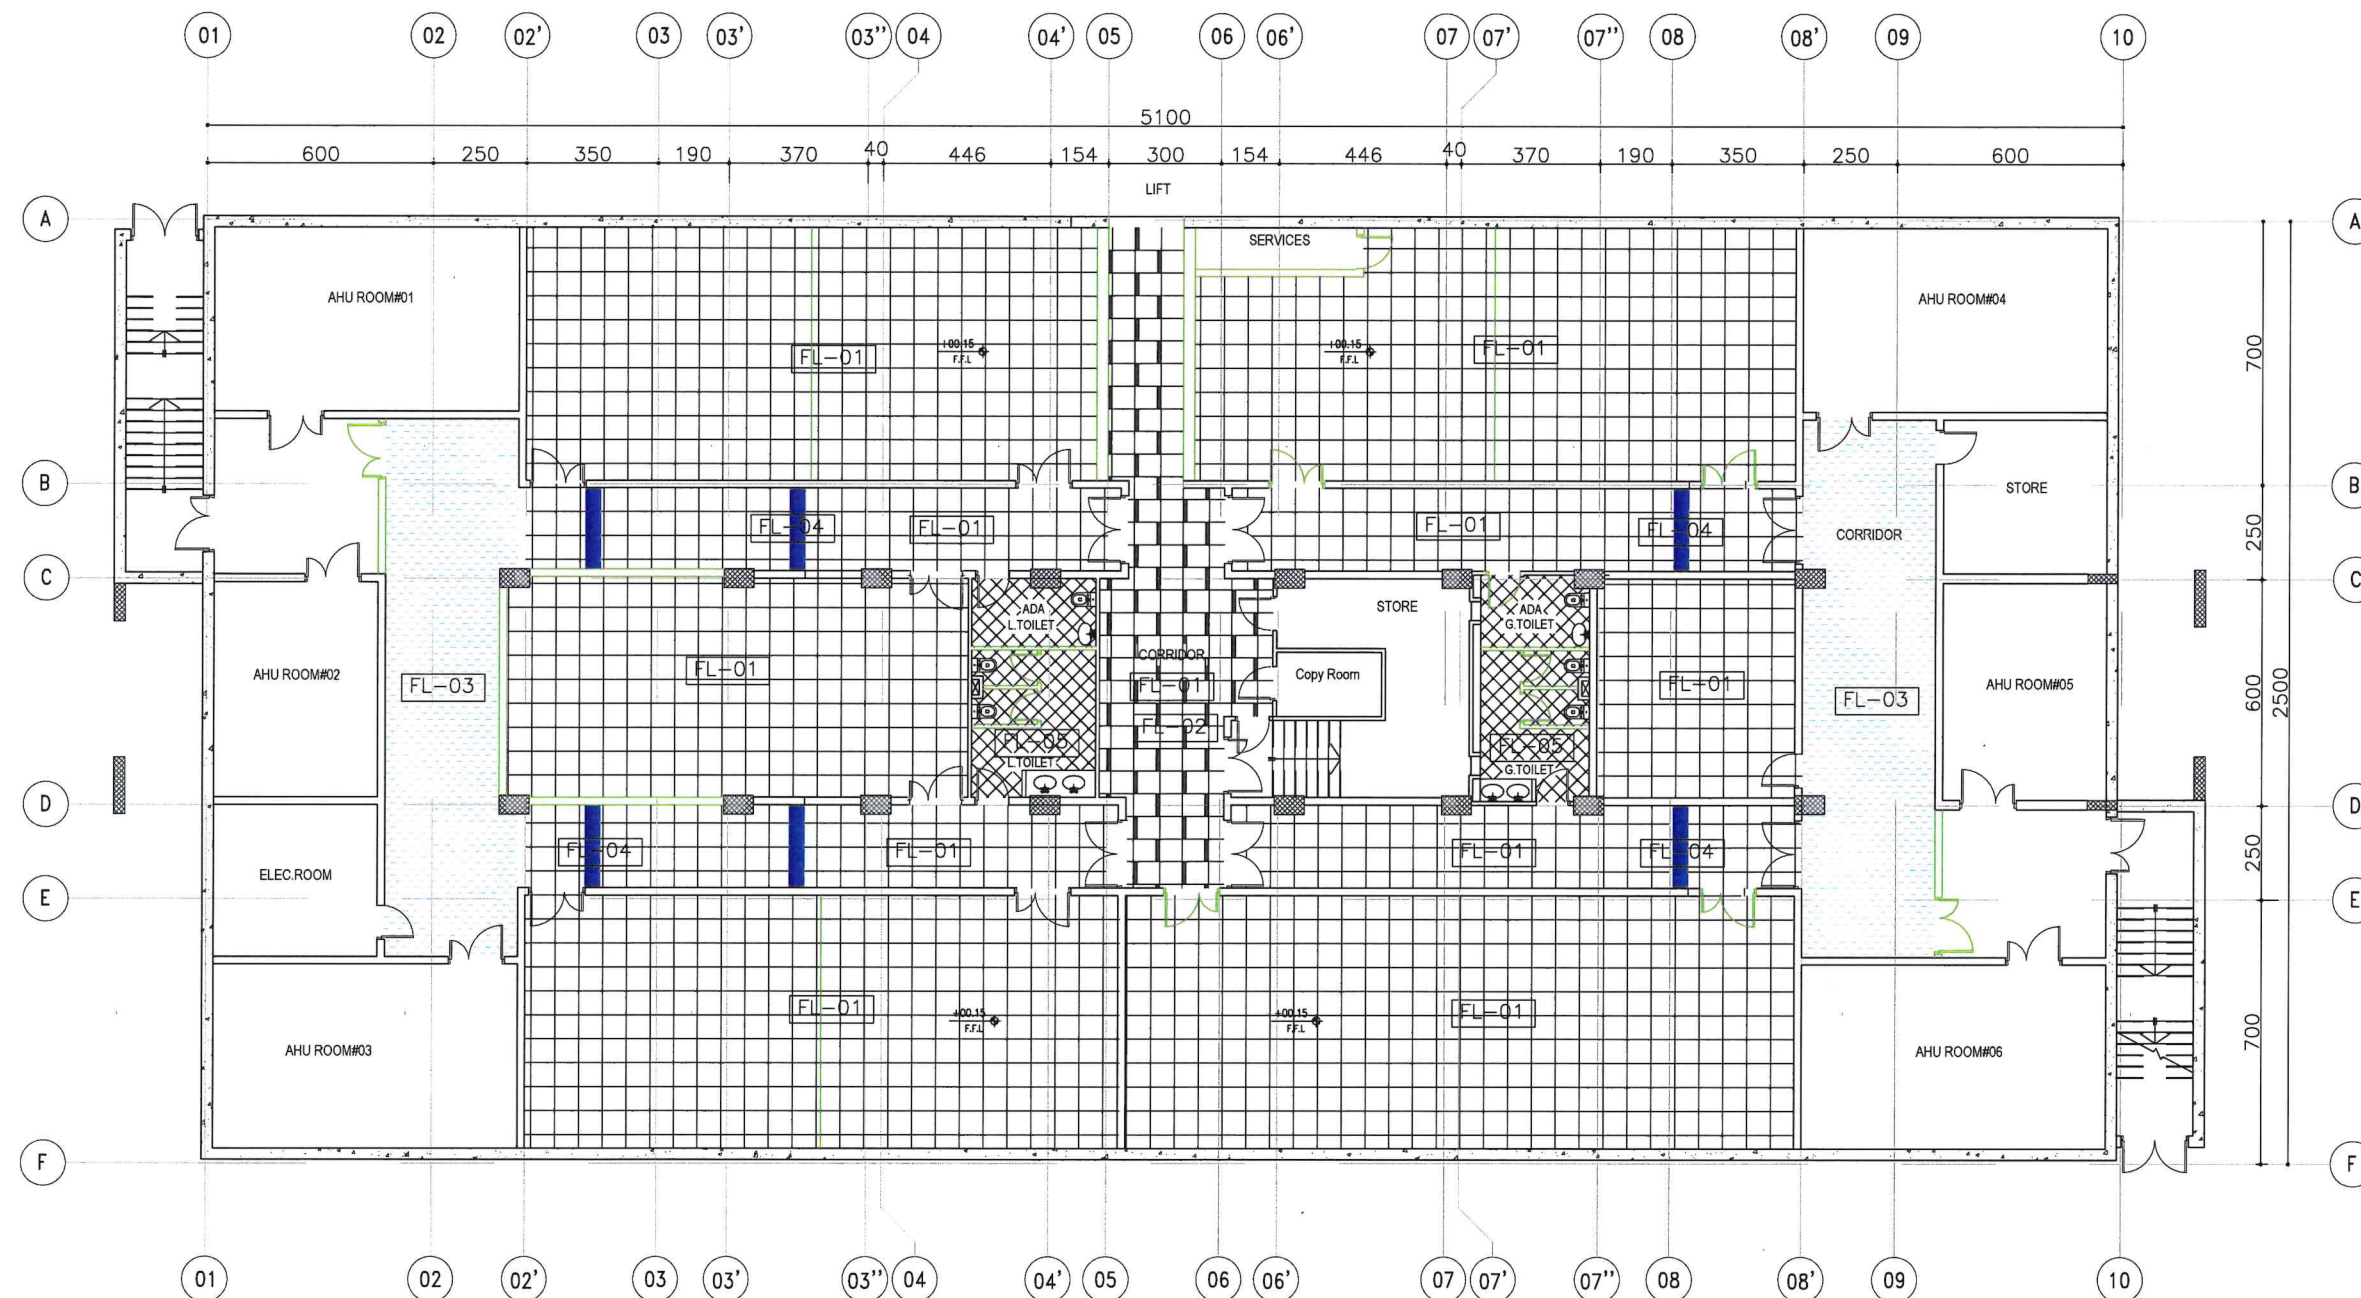

	FL-01	*CERAMIC GREY TILES 600X600MM or 1200X600MM
	FL-02	*CERAMIC DARK GREY TILES 600X600MM
	FL-03	*BLUE CARPET TILES
	FL-04	*CERAMIC DARK BLUE TILES 400X400MM
	FL-05	*CERAMIC GREY TILES 600X600MM


DATE	REVISIONS	DATE	APPROVED

ABDULLAH AL SALEM UNIVERSITY
FACILITIES MANAGEMENT
& ENGINEERING AFFAIRS

PROJECT TITLE:-
KH-11
Class Rooms (C.O.S)

DRAWING TITLE:-
BASEMENT FLOOR
FLOORING PATTERN

CHECKED BY	SERVICES	CIVIL	ARCH.	SCALE
ENG, ALAA				1:100
APPROVED BY	DRAWN BY	HVAC	ELEC.	DATE
ENG, FATHI	AHMED			MAY. 2014

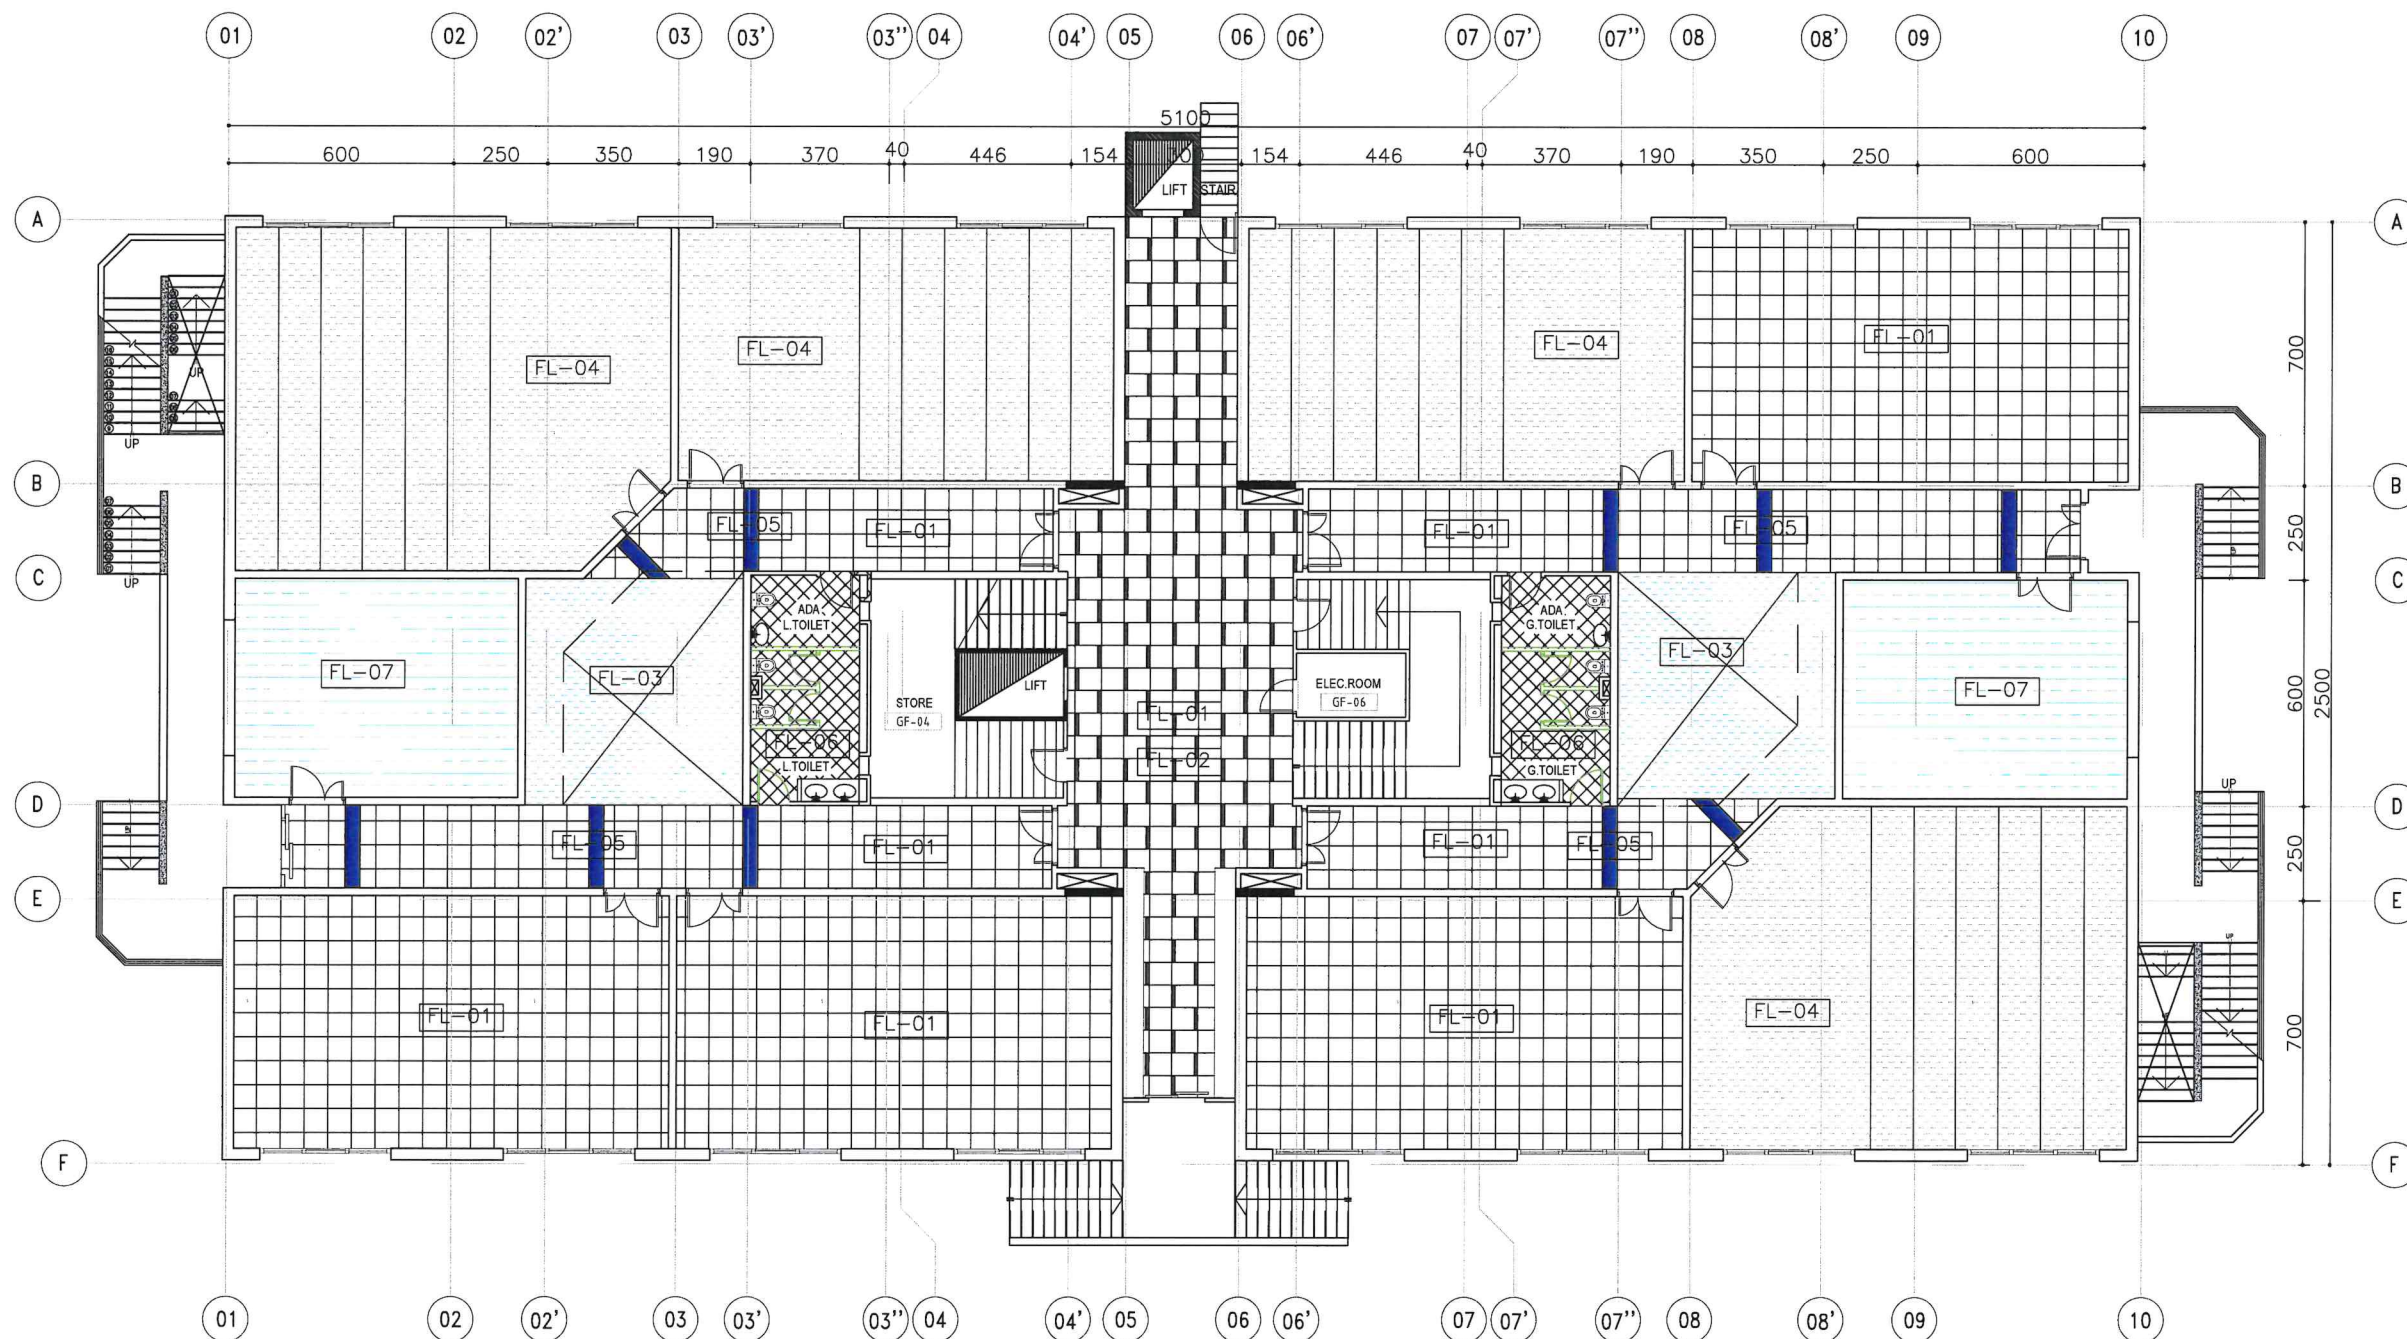

	FL-01	*CERAMIC GREY TILES 600X600MM or 1200X600MM
	FL-02	*CERAMIC DARK GREY TILES 600X600MM
	FL-03	*BLUE CARPET TILES
	FL-04	*GREY CARPET TILES
	FL-04	*CERAMIC DARK BLUE TILES 400X400MM
	FL-06	*CERAMIC GREY TILES 600X600MM
	FL-07	*PRAYER ROOM CARPET

DATE	REVISIONS	DATE	APPROVED


ABDULLAH AL SALEM UNIVERSITY
FACILITIES MANAGEMENT
& ENGINEERING AFFAIRS

PROJECT TITLE:-
KH-11
Class Rooms (C.O.S)

DRAWING TITLE:-
GROUND FLOOR FLOORING

DRAWING NO.

CHECKED BY	SERVICES	CIVIL	ARCH.	SCALE
				1:100
APPROVED BY	DRAWN BY	HVAC	ELEC.	DATE

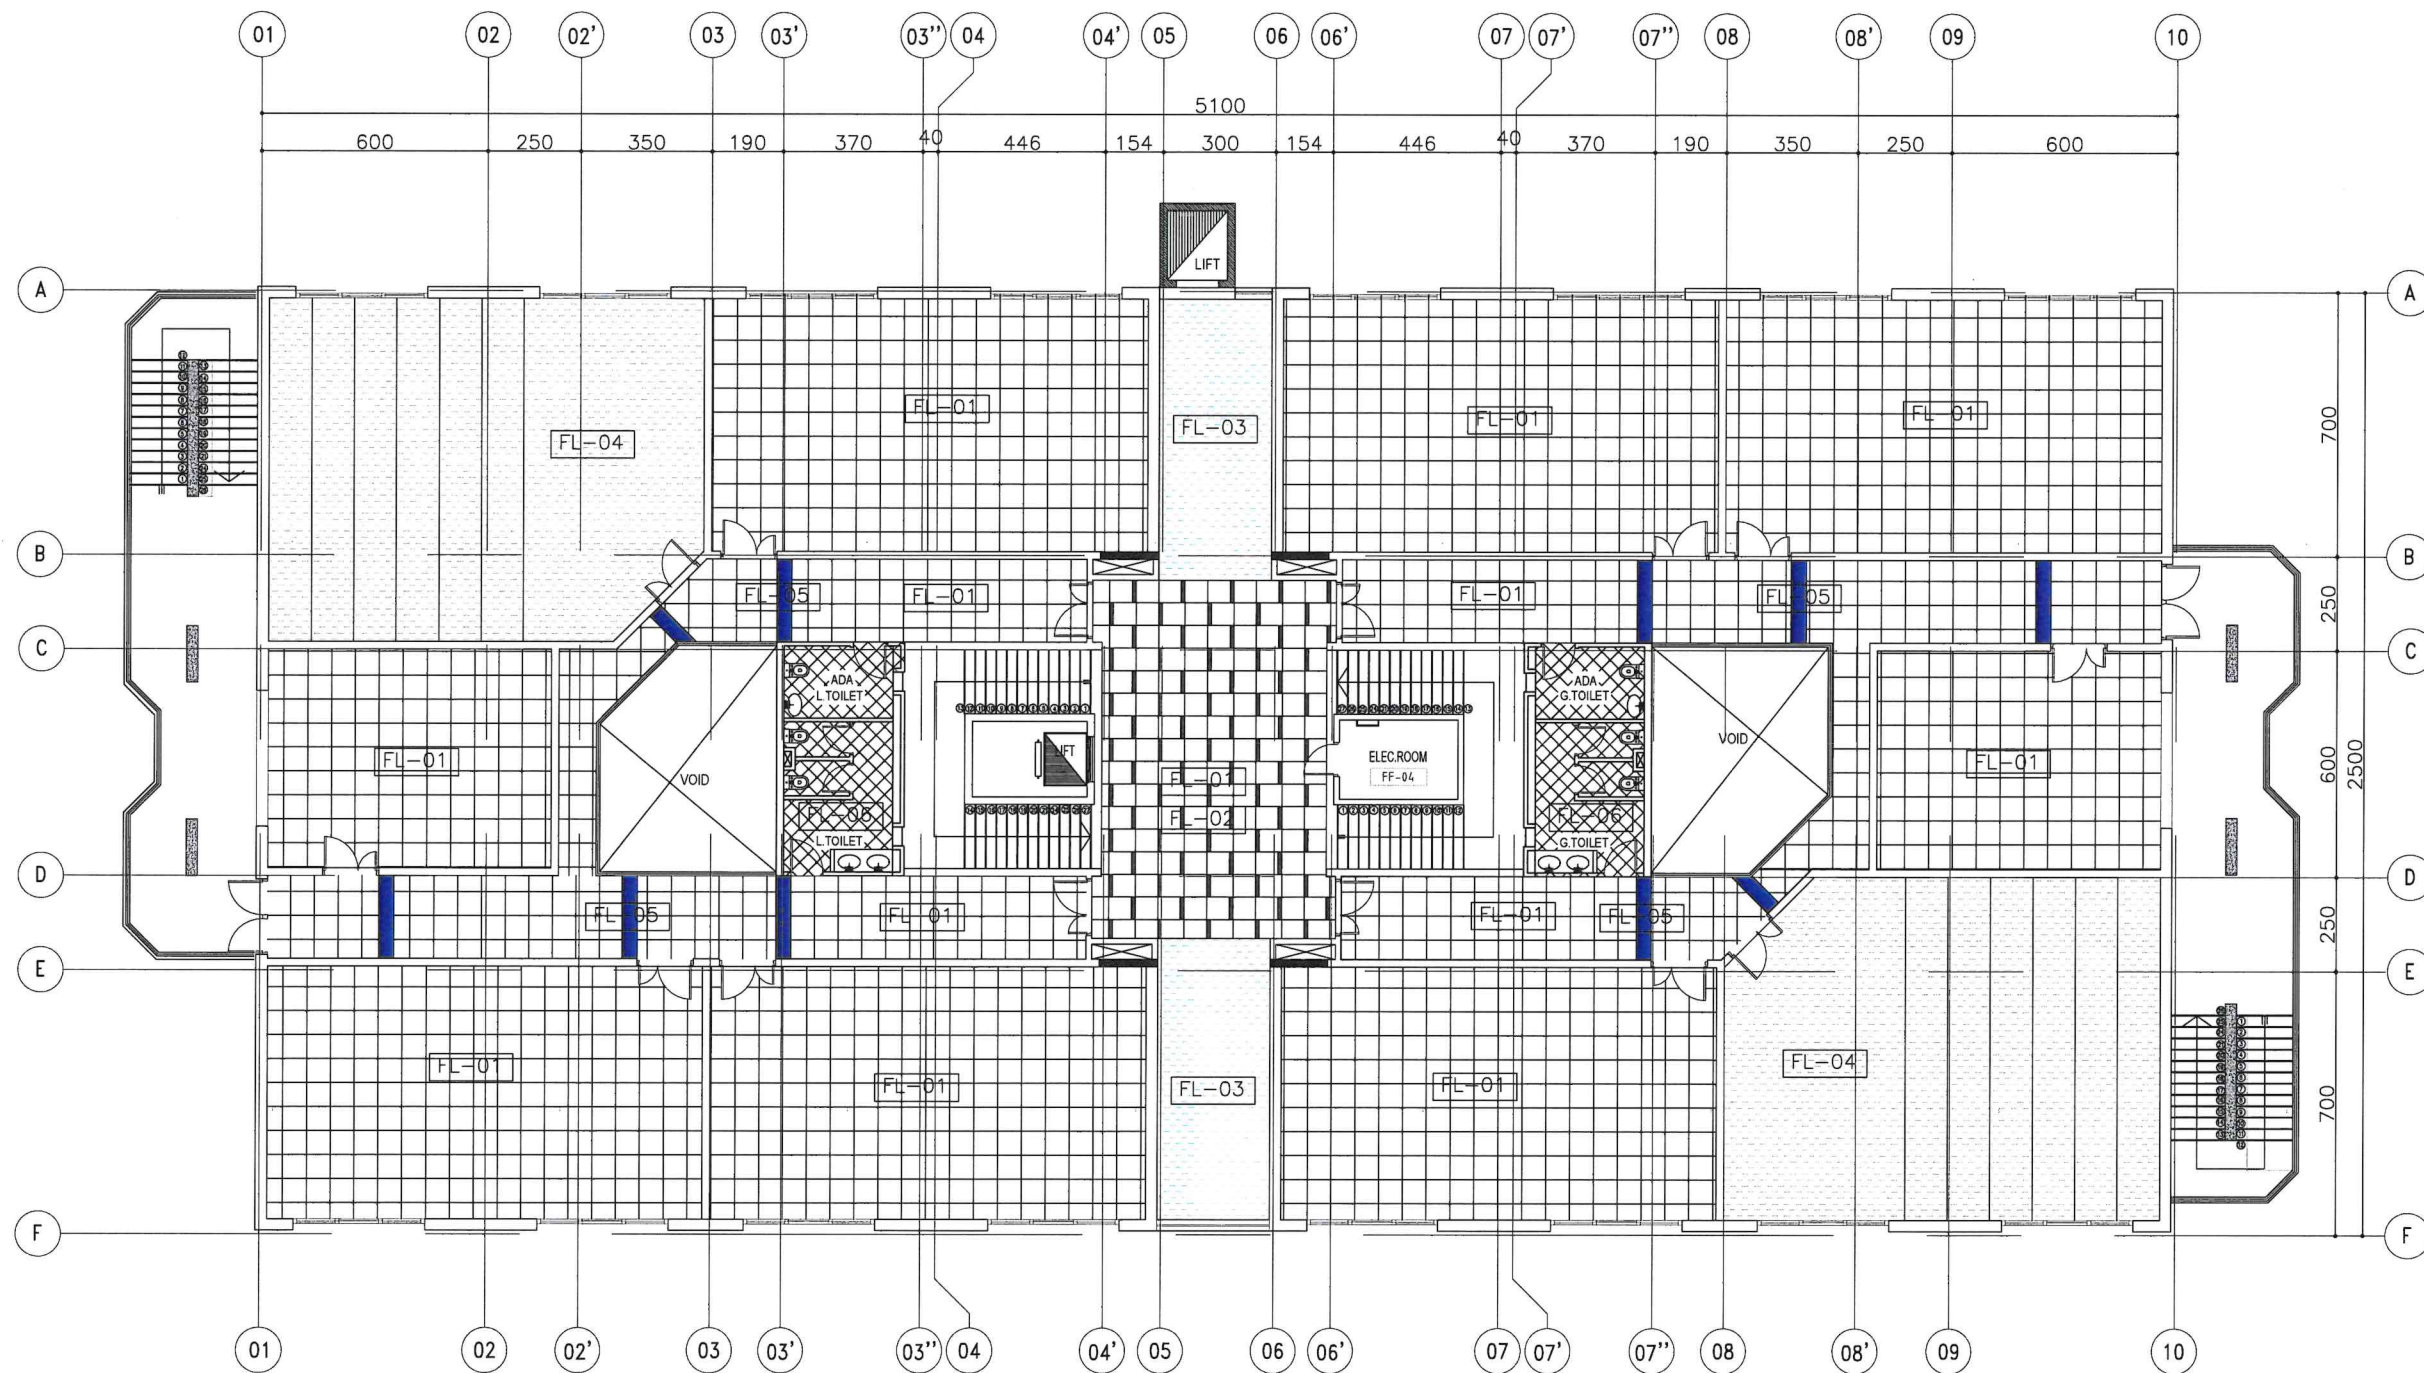

	FL-01	*CERAMIC GREY TILES 600X600MM or 1200X600MM
	FL-02	*CERAMIC DARK GREY TILES 600X600MM
	FL-03	*BLUE CARPET TILES
	FL-04	*GREY CARPET TILES
	FL-05	*CERAMIC DARK BLUE TILES 400X400MM
	FL-06	*CERAMIC GREY TILES 600X600MM



DATE	REVISIONS	DATE	APPROVED

ABDULLAH AL SALEM UNIVERSITY
FACILITIES MANAGEMENT
& ENGINEERING AFFAIRS

PROJECT TITLE:-
KH-11
Class Rooms (C.O.S)

DRAWING TITLE:-
FIRST FLOOR FLOORING

CHECKED BY	SERVICES	CIVIL	ARCH.	SCALE
ENG, ALAA				1:100
APPROVED BY	DRAWN BY	HVAC	ELEC.	DATE
ENG, FATHI	AHMED			MAY. 2014

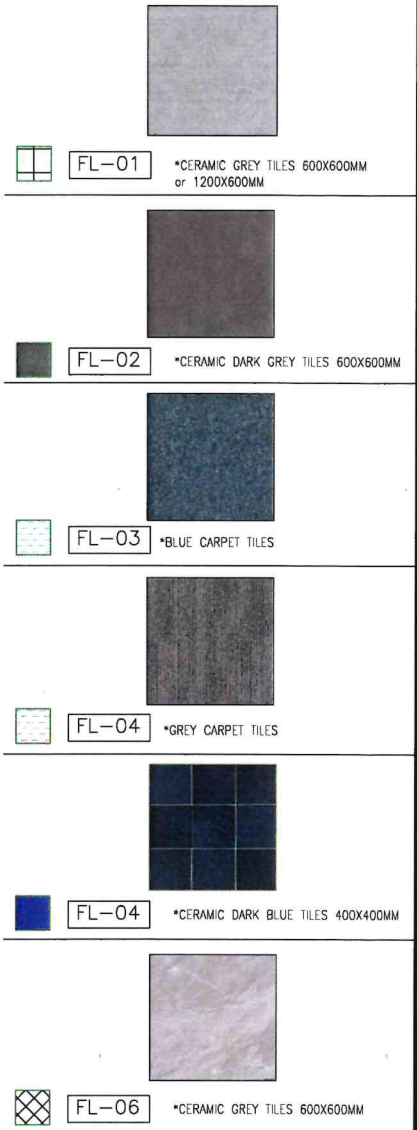
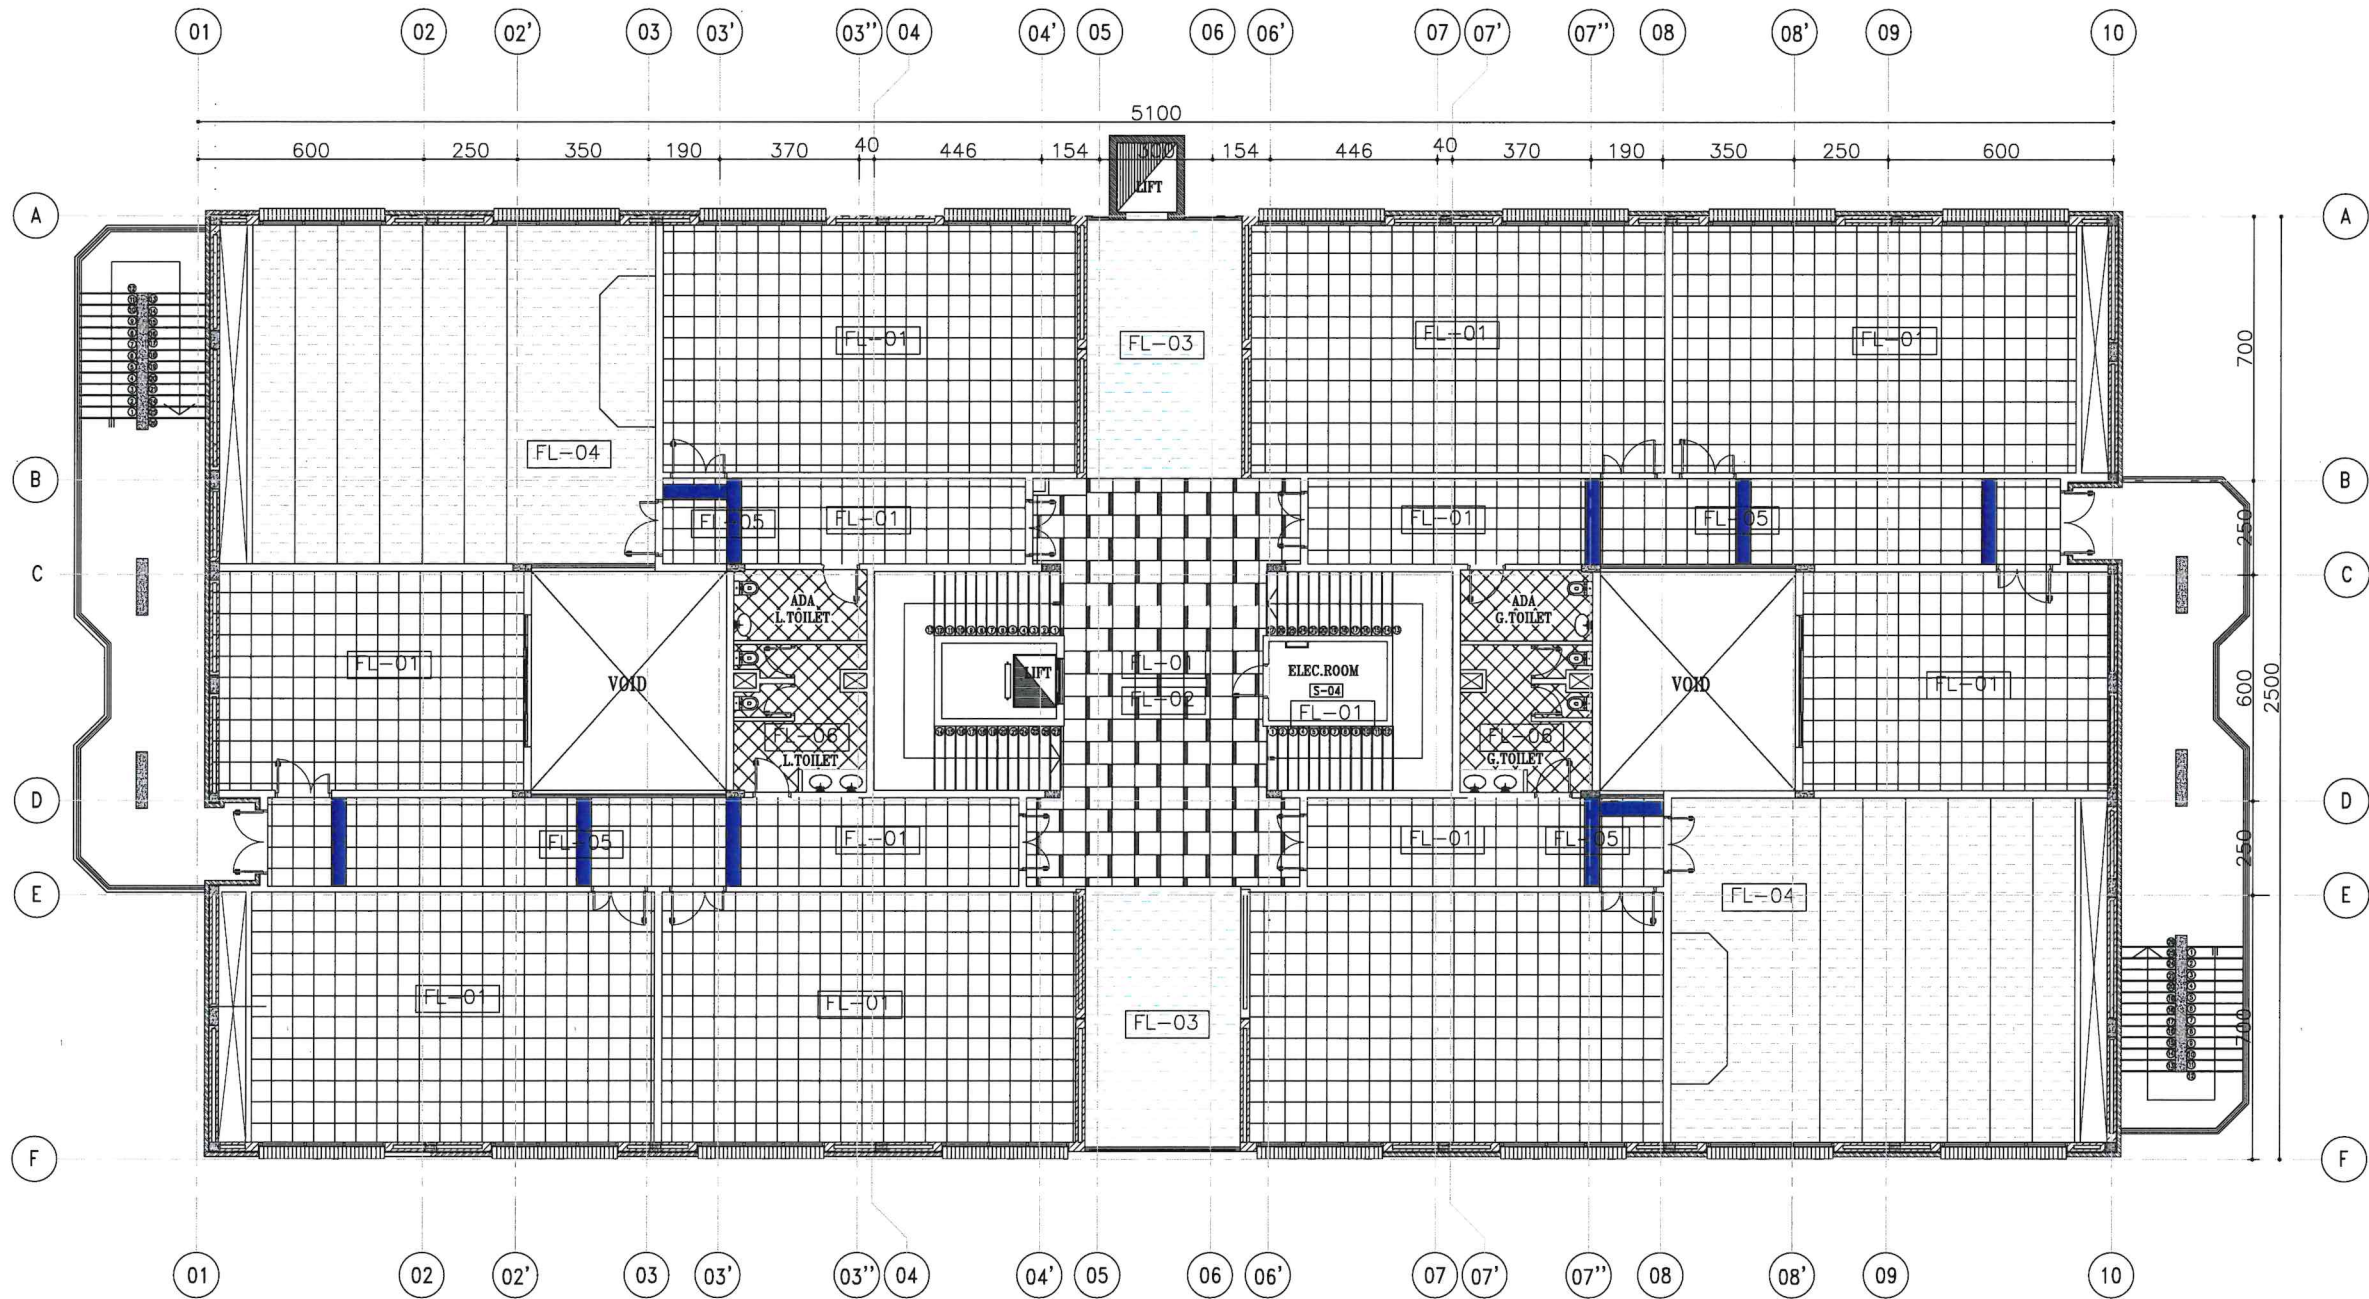


DATE	REVISIONS	DATE	APPROVED
ABDULLAH AL SALEM UNIVERSITY FACILITIES MANAGEMENT & ENGINEERING AFFAIRS			
PROJECT TITLE:- KH-11 Class Rooms (C.O.S)			
DRAWING TITLE:- SECOND FLOOR FLOORING			DRAWING NO.
CHECKED BY	SERVICES	CIVIL	ARCH.
APPROVED BY			SCALE
			1:100
DRAWN BY			DATE
			MAY.2014

Power & Internet Plan



ORIENTATION

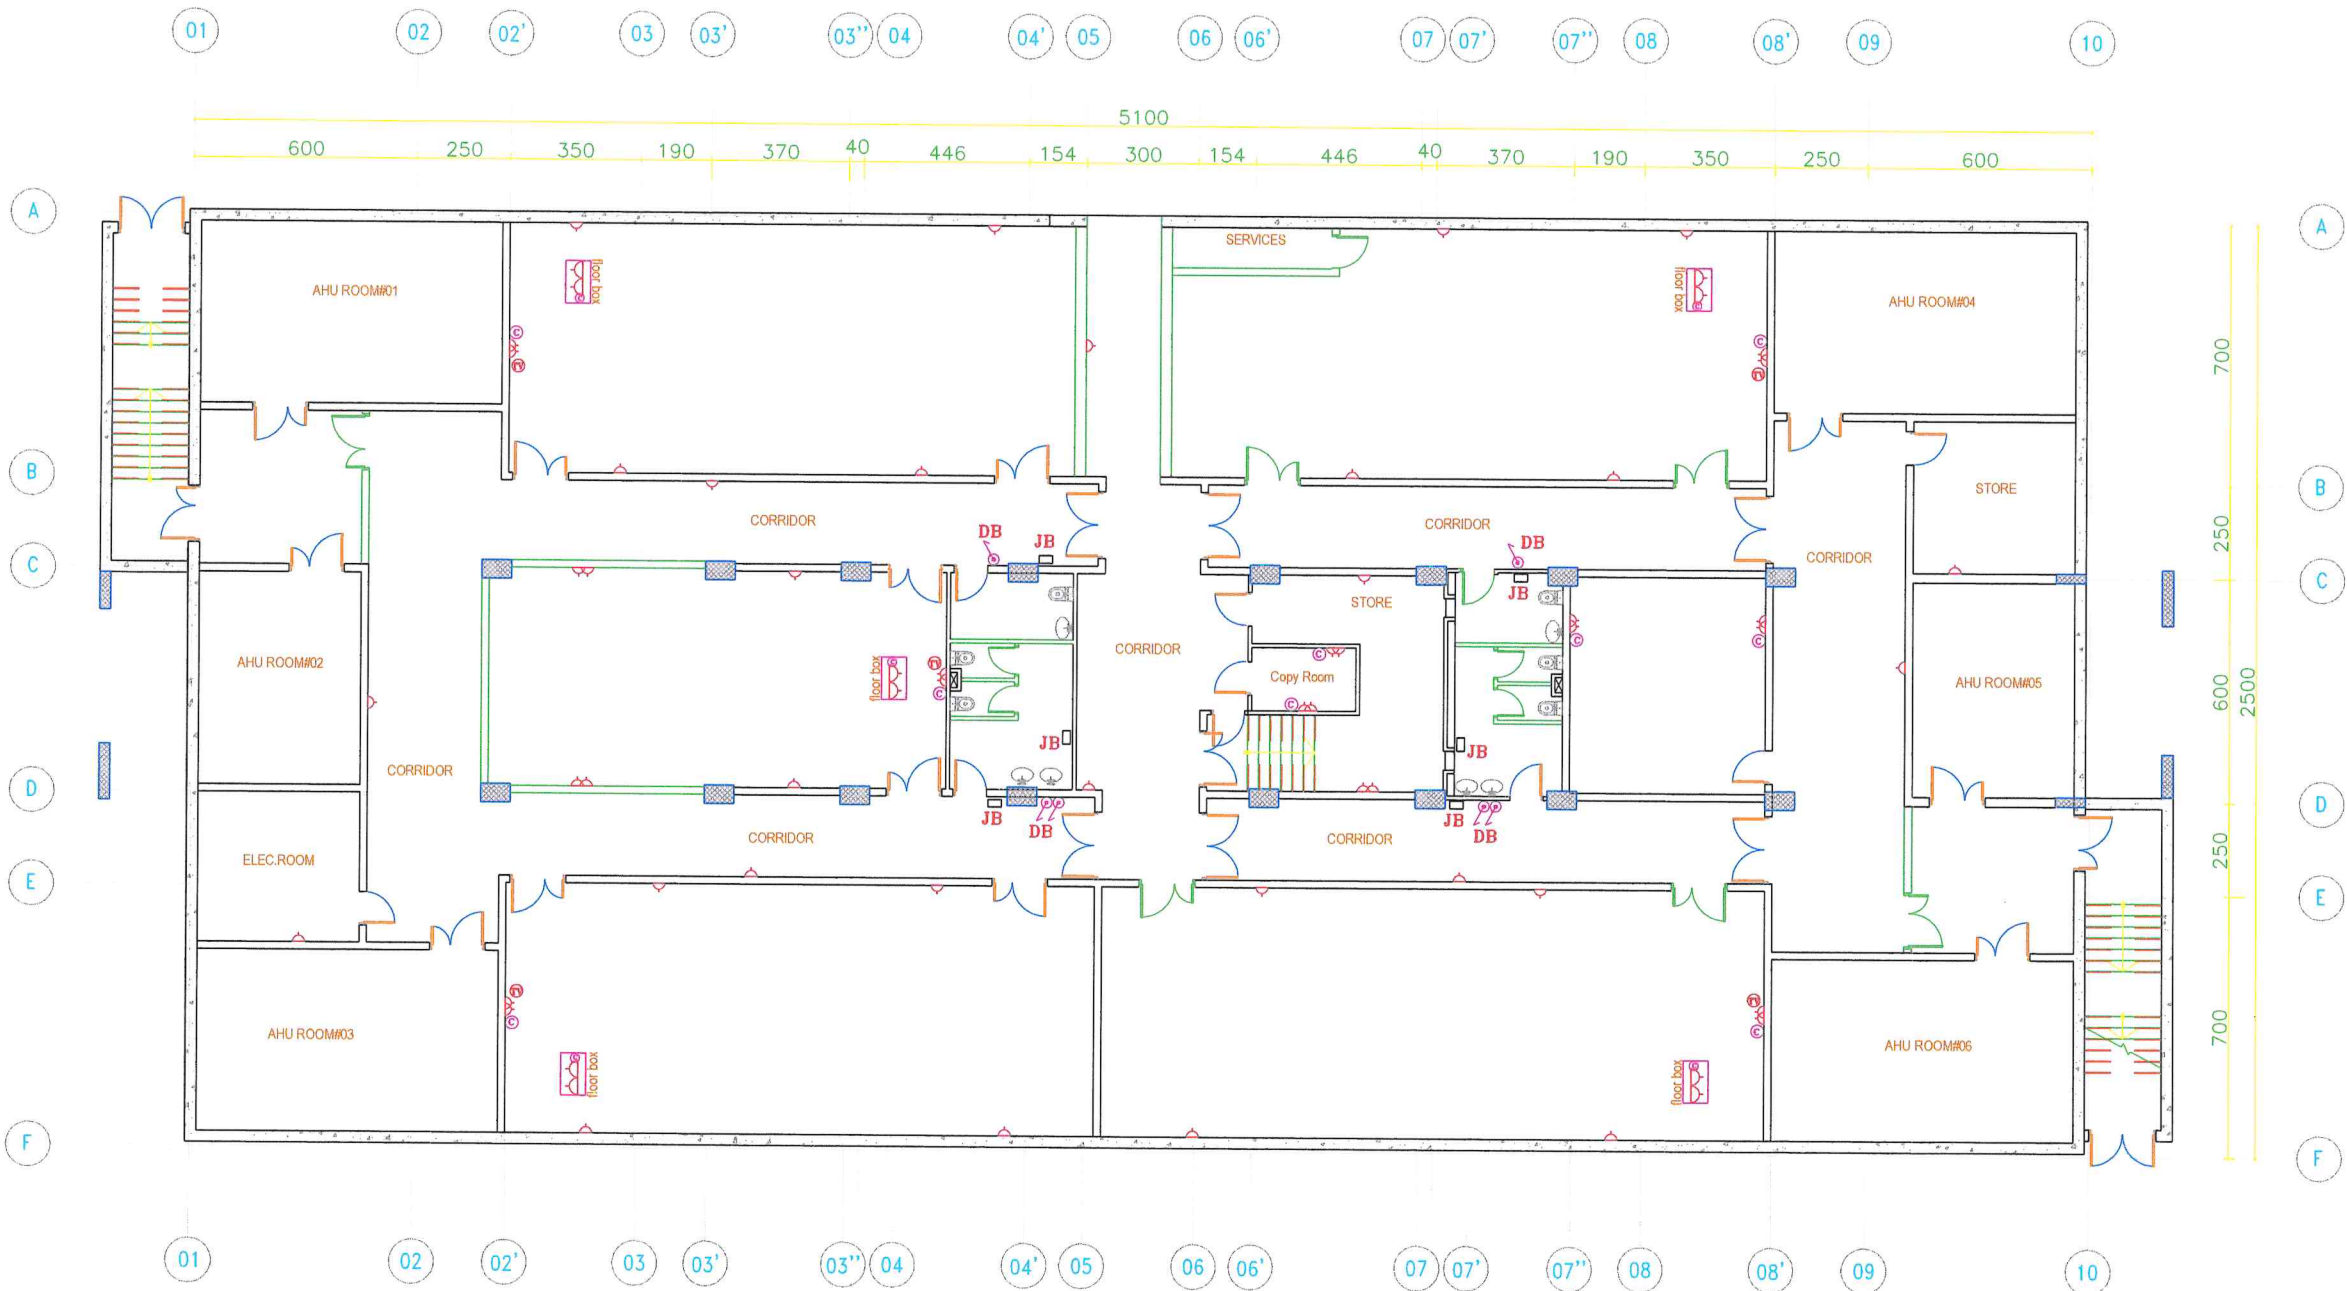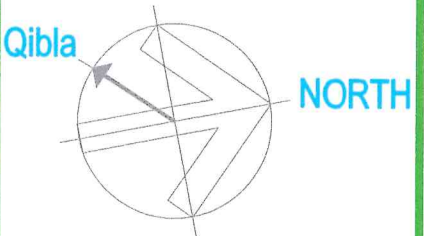

ITEM REF.		ITEM DESCRIPTION	QTY	UNIT
1	⊙	DATA POINT	12	Nos
2	⚡	13A, SWITCH TWIN SOCKET	13	Nos
3	⚡	13A, SWITCH SOCKET	27	Nos
4	DB	DISTRIBUTION BOARD (D.B)	6	Nos
5	JB	15A J.B WITH D.P SWITCH FOR W.H.A.C	6	Nos
6	⌚	FLOOR BOX	5	Nos

DATE	REVISIONS	DATE	APPROVED


ABDULLAH AL SALEM UNIVERSITY
FACILITIES MANAGEMENT
& ENGINEERING AFFAIRS

PROJECT TITLE:-
KH-11
Class Rooms (C.O.S)

DRAWING TITLE:-				DRAWING NO.
BASEMENT FLOOR ELECTRICAL PLAN				
POWER & INTERNET				
CHECKED BY	SERVICES	CIVIL	ARCH.	SCALE
ENG.ALA				1:100
APPROVED BY	DRAWN BY	HVAC	ELEC.	DATE.
ENG.FATHI	AHMED			MAY.2014



ORIENTATION

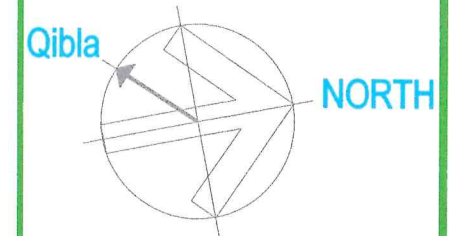


ITEM REF.		ITEM DESCRIPTION	QTY	UNIT
1	⊙	DATA POINT	16	Nos
2	⚡	13A, SWITCH TWIN SOCKET	22	Nos
3	⚡	13A, SWITCH SOCKET	39	Nos
4	DB	DISTRIBUTION BOARD (D.B)	10	Nos
5	JB	15A JB WITH D.P SWITCH FOR W.H.VAC	10	Nos
6	⬜	FLOOR BOX	8	Nos

DATE	REVISIONS	DATE	APPROVED

ABDULLAH AL SALEM UNIVERSITY
FACILITIES MANAGEMENT
& ENGINEERING AFFAIRS



PROJECT TITLE:-
**KH-11
Class Rooms (C.O.S)**

DRAWING TITLE:-	DRAWING NO.
GROUND FLOOR ELECTRIC POWER & INTERNET	
CHECKED BY SERVICES CIVIL ARCH. SCALE	
ENG. ALAA	1:100
APPROVED BY DRAWN BY HVAC ELEC. DATE.	
ENG. PATHI AHMED	MAY. 2014

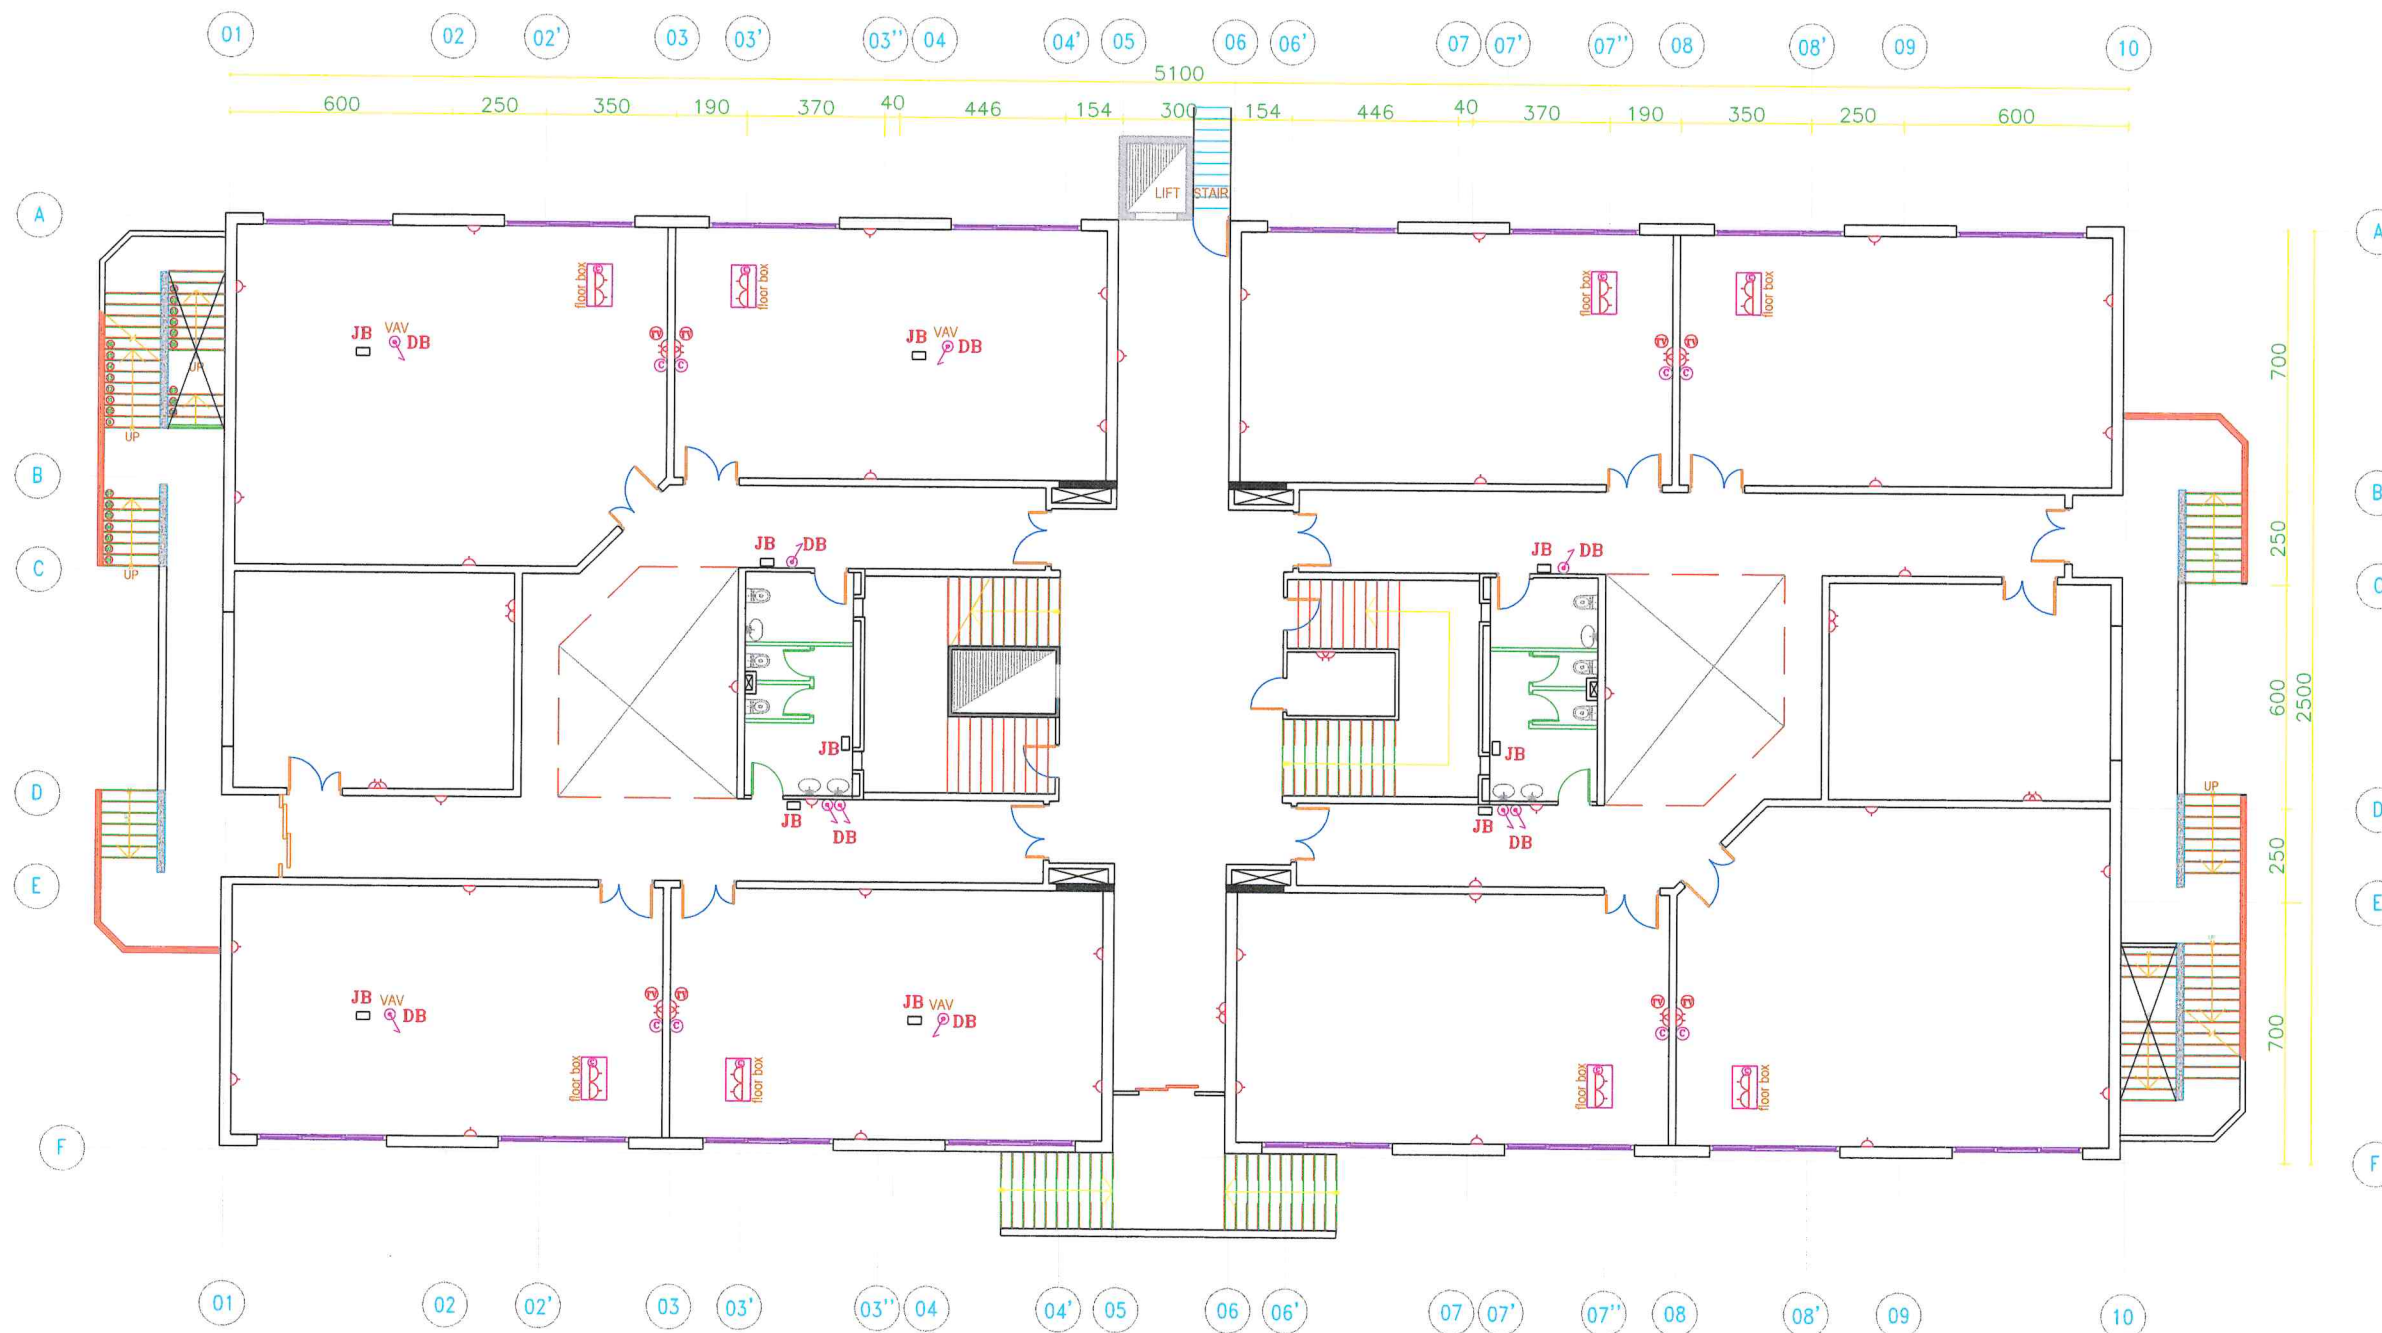



ORIENTATION

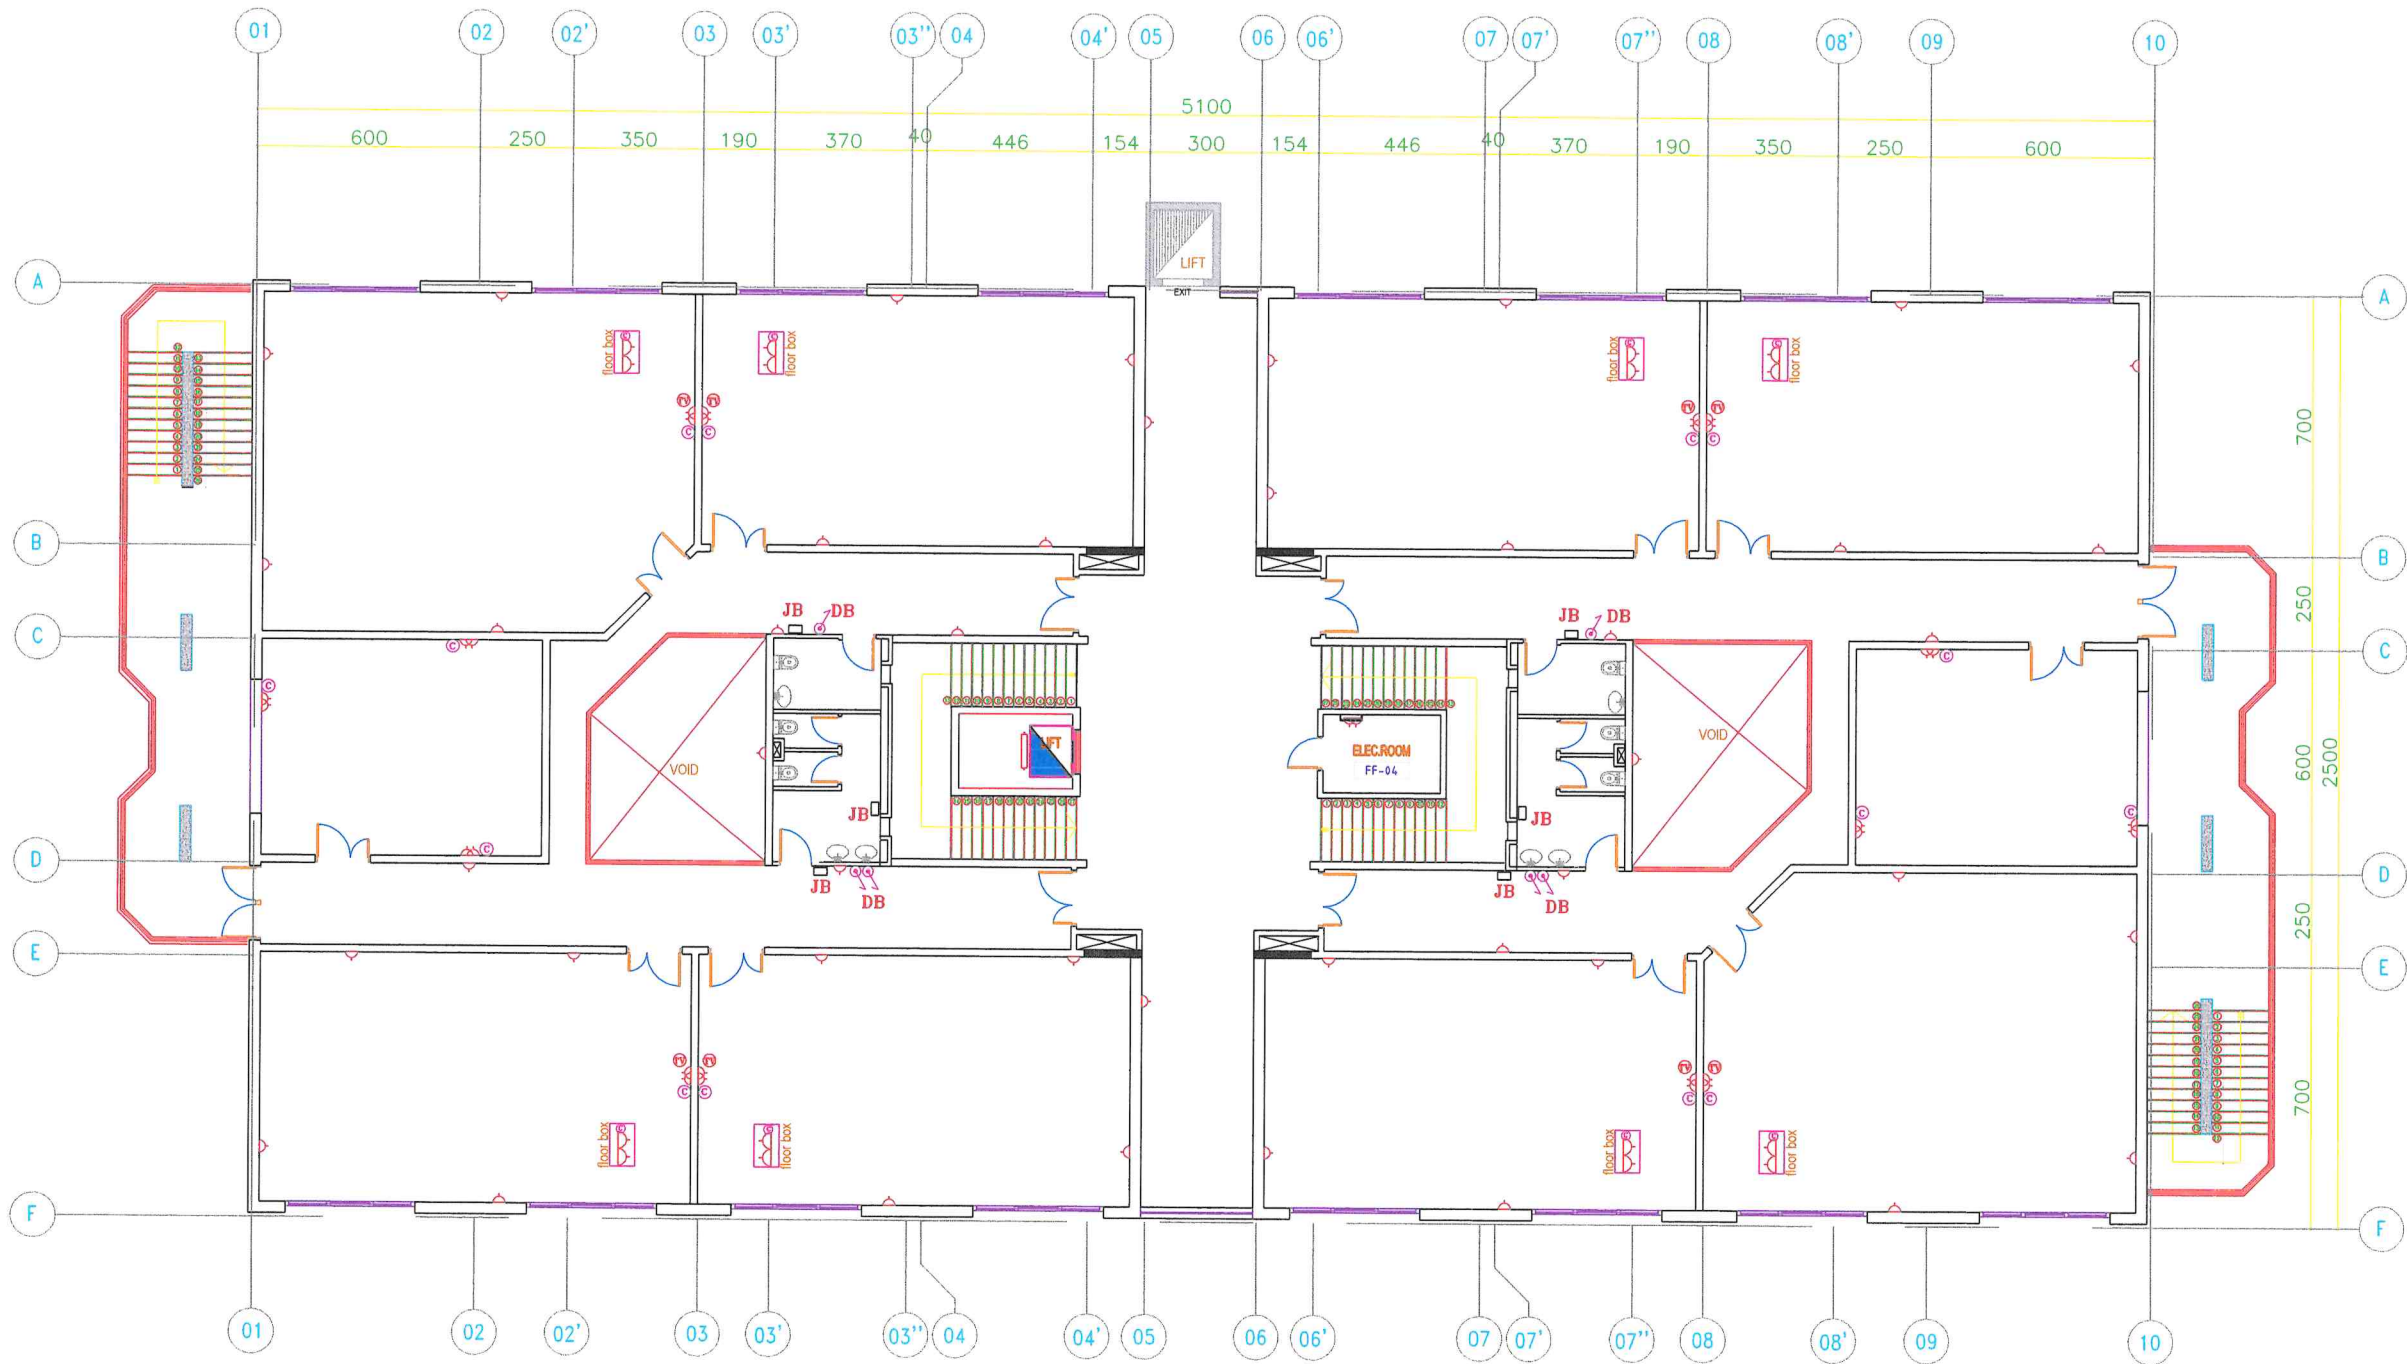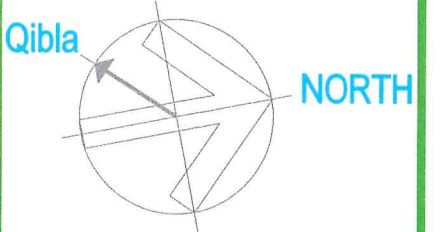

ITEM REF.	ITEM DESCRIPTION	QTY	UNIT
1	DATA POINT	22	Nos
2	13A, SWITCH TWIN SOCKET	22	Nos
3	13A, SWITCH SOCKET	42	Nos
4	DB 7 DISTRIBUTION BOARD (D.B)	6	Nos
5	JB 15A J.B WITH D.P SWITCH FOR W.H.VAC	6	Nos
6	FLOOR BOX	8	Nos

DATE	REVISIONS	DATE	APPROVED



ABDULLAH AL SALEM UNIVERSITY
FACILITIES MANAGEMENT
& ENGINEERING AFFAIRS

PROJECT TITLE:-
KH-11
Class Rooms (C.O.S)

DRAWING TITLE:-				DRAWING NO.
FIRST FLOOR ELECTRIC POWER & INTERNET				
CHECKED BY	SERVICES	CIVIL	ARCH.	SCALE
ENG, ALAA				1:100
APPROVED BY	DRAWN BY	HVAC	ELEC.	DATE
ENG, PATHI	AHMED			MAY.2014



ORIENTATION

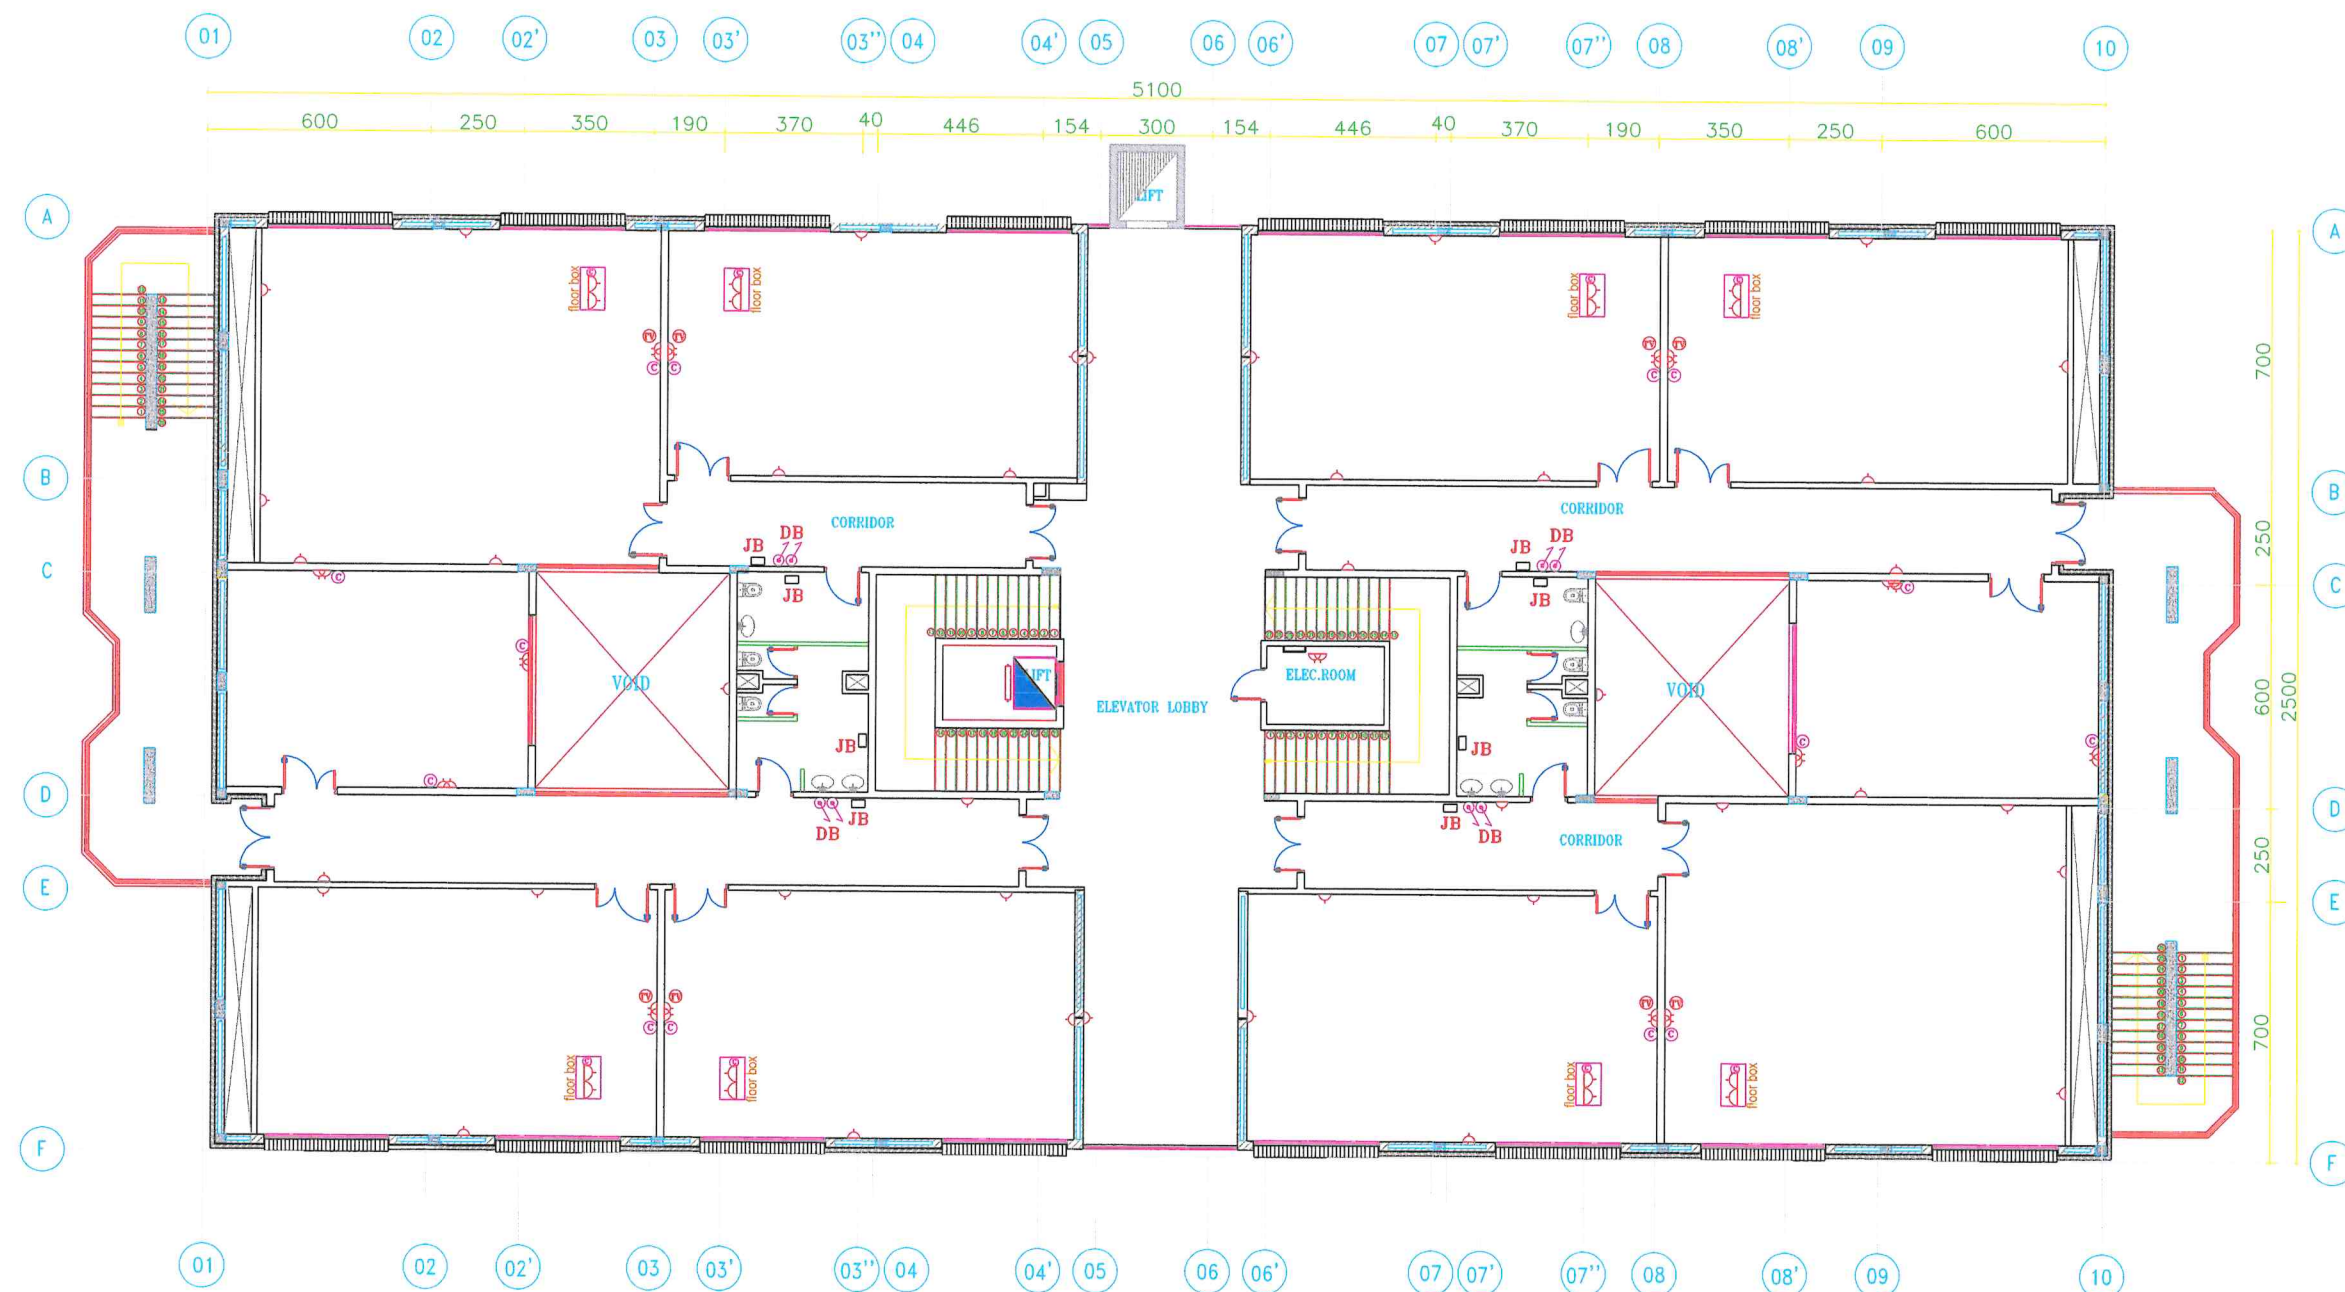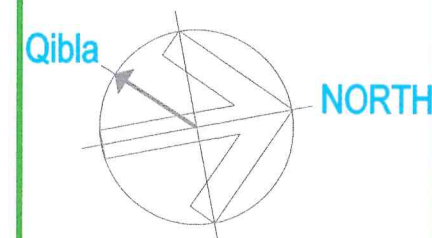

ITEM REF.	ITEM DESCRIPTION	QTY	UNIT
1	DATA POINT	22	Nos
2	13A, SWITCH TWIN SOCKET	24	Nos
3	13A, SWITCH SOCKET	36	Nos
4	DB DISTRIBUTION BOARD (D.B)	8	Nos
5	JB 15A JB WITH D.P SWITCH FOR W.H.VAC	8	Nos
6	FLOOR BOX	8	Nos

DATE	REVISIONS	DATE	APPROVED

ABDULLAH AL SALEM UNIVERSITY
FACILITIES MANAGEMENT
& ENGINEERING AFFAIRS

PROJECT TITLE:-
KH-11
Class Rooms (C.O.S)

DRAWING TITLE:-
SECOND FLOOR ELECTRIC
POWER & INTERNET

CHECKED BY: SERVICES CIVIL ARCH. SCALE: 1:100

APPROVED BY: DRAWN BY: HVAC ELEC. DATE: MAY.2014



Reflected Ceiling Plan





- *FELT ACOUSTIC LIGHT BLUE PANEL 600X600MM
- *FELT ACOUSTIC DARK BLUE PANEL 600X600MM
- *ACOUSTIC TILES 600X600MM
- *GYPSUM BOARD CEILING

DATE	REVISIONS	DATE	APPROVED
ABDULLAH AL SALEM UNIVERSITY FACILITIES MANAGEMENT & ENGINEERING AFFAIRS			
PROJECT TITLE:- KH-11 Class Rooms (C.O.S)			
DRAWING TITLE:- BASEMENT FLOOR REFLECTED CEILING			DRAWING NO.
CHECKED BY	SERVICES	CIVIL	ARCH.
ENG,ALAA			
APPROVED BY			SCALE
ENG,FATHI	AHMED		1:100
DRAWN BY			DATE
			MAY.2014

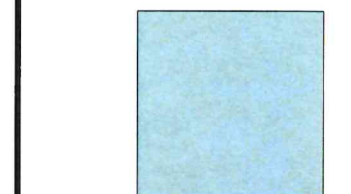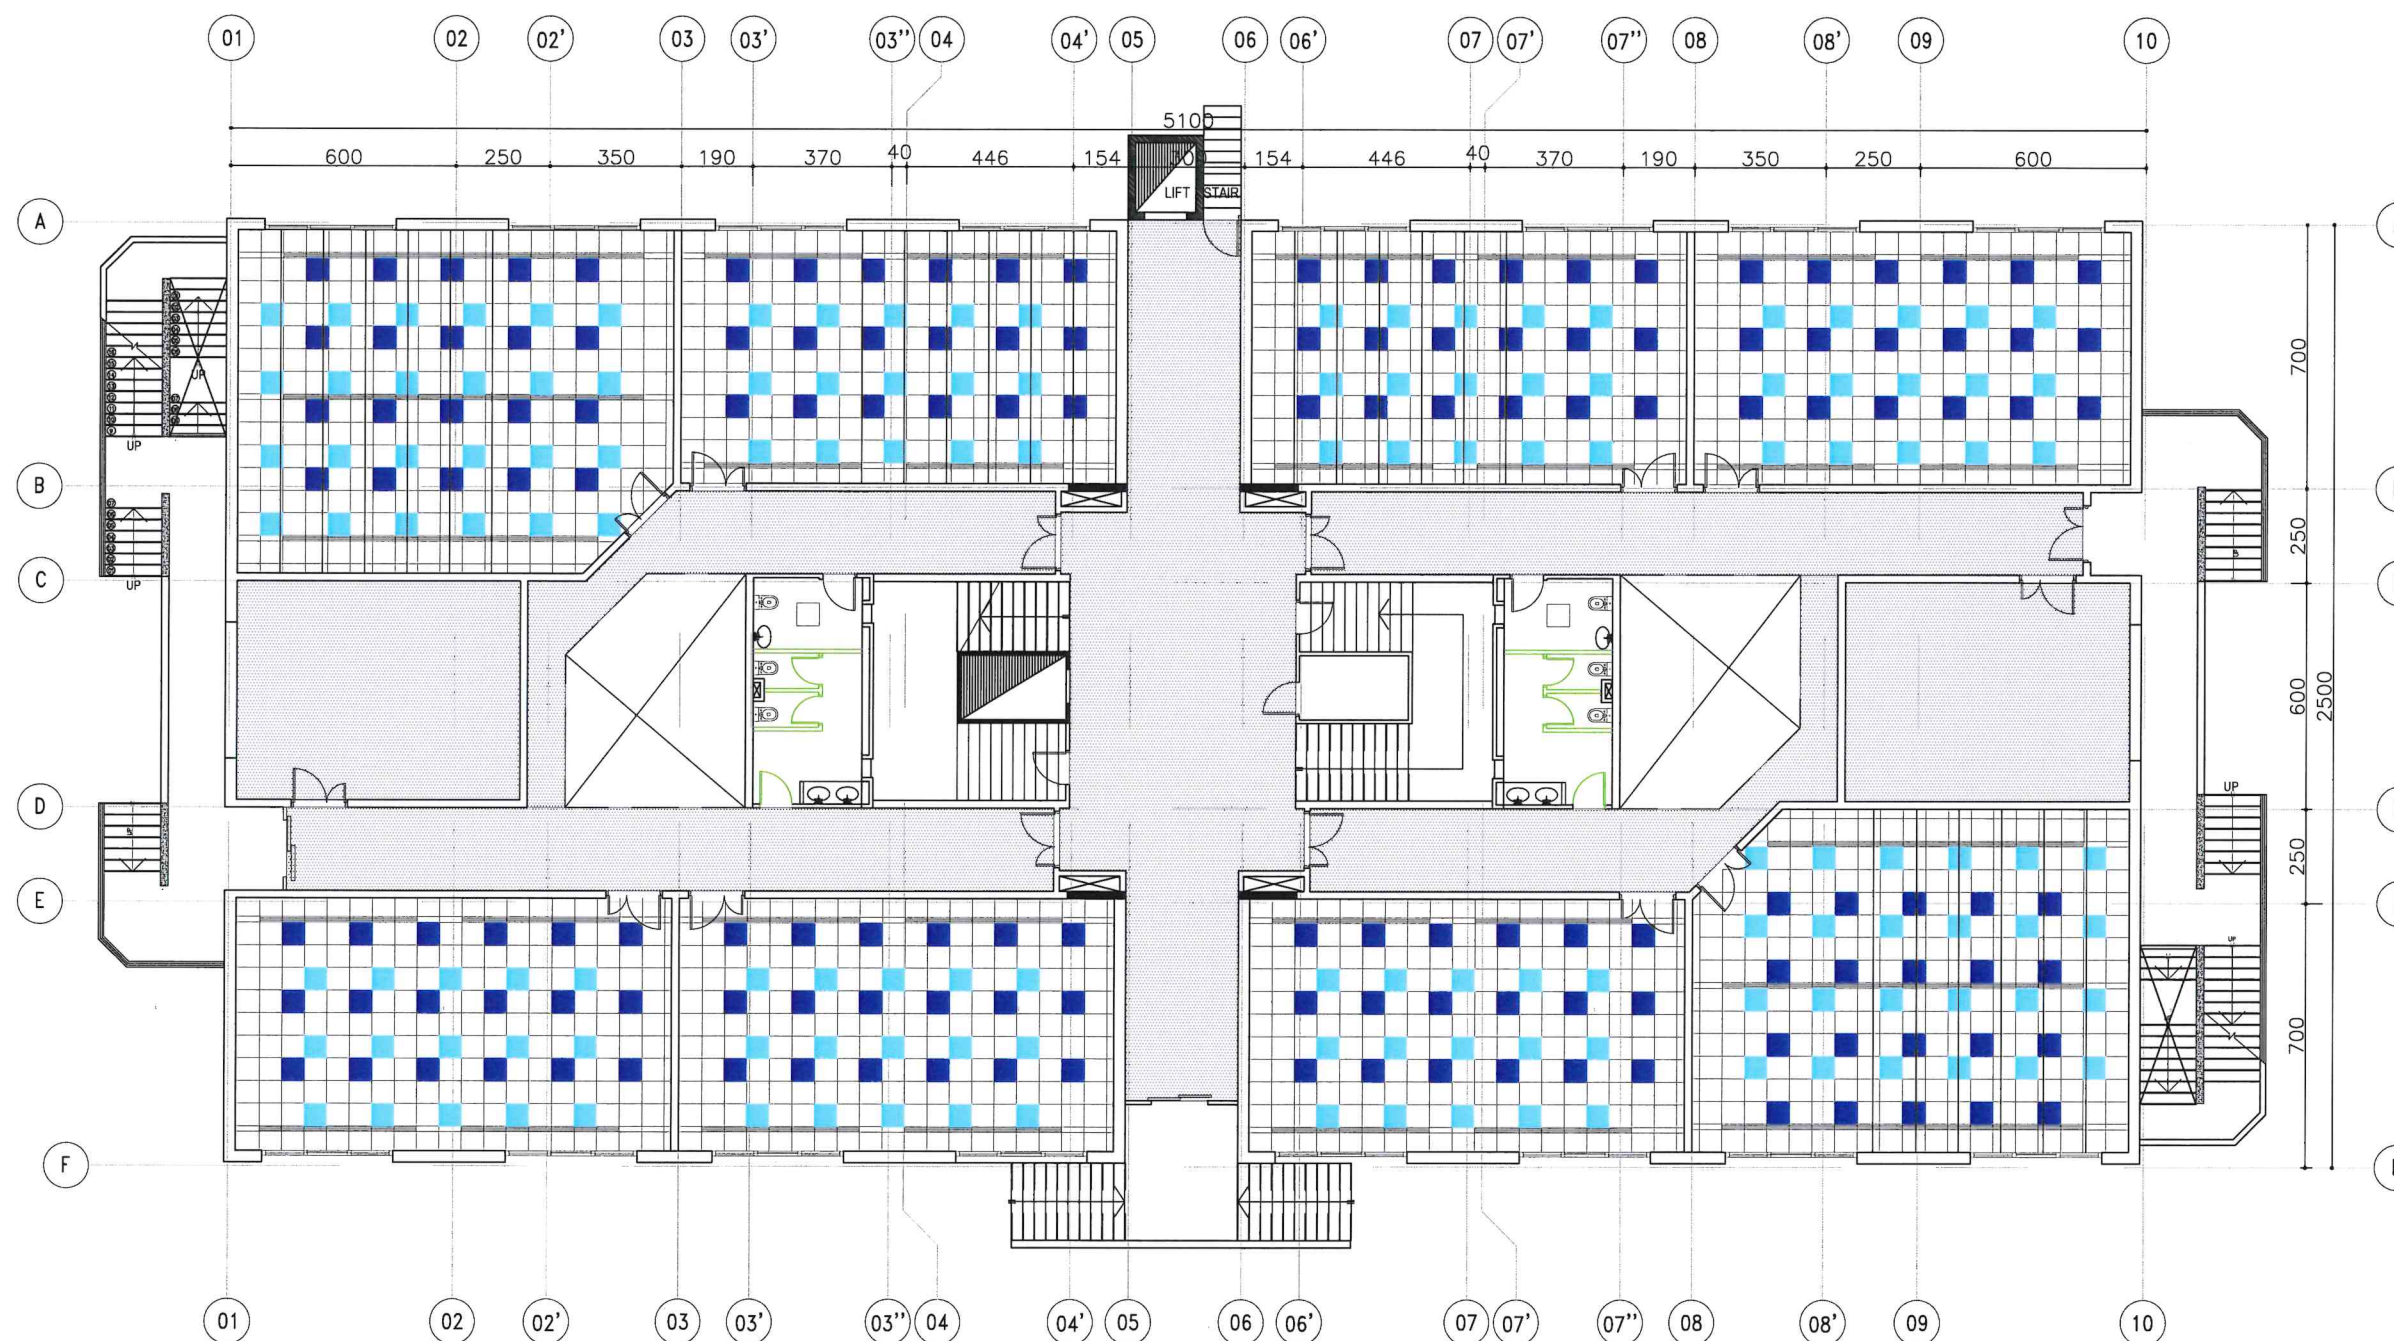

*FELT ACOUSTIC LIGHT BLUE PANEL 600X600MM



*FELT ACOUSTIC DARK BLUE PANEL 600X600MM



*ACOUSTIC TILES 600X600MM

*GYPSUM BOARD CEILING

DATE	REVISIONS	DATE	APPROVED

ABDULLAH AL SALEM UNIVERSITY
FACILITIES MANAGEMENT
& ENGINEERING AFFAIRS



PROJECT TITLE:-
KH-11
Class Rooms (C.O.S)

DRAWING TITLE:-
GROUND FLOOR
REFLECTED CEILING

DRAWING NO.

CHECKED BY	SERVICES	CIVIL	ARCH.	SCALE
ENG, ALAA				1:100

APPROVED BY	DRAWN BY	HVAC	ELEC.	DATE
ENG, FATHI	AHMED			MAY.2014

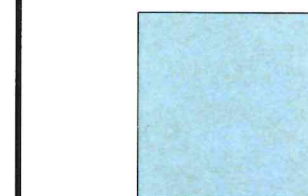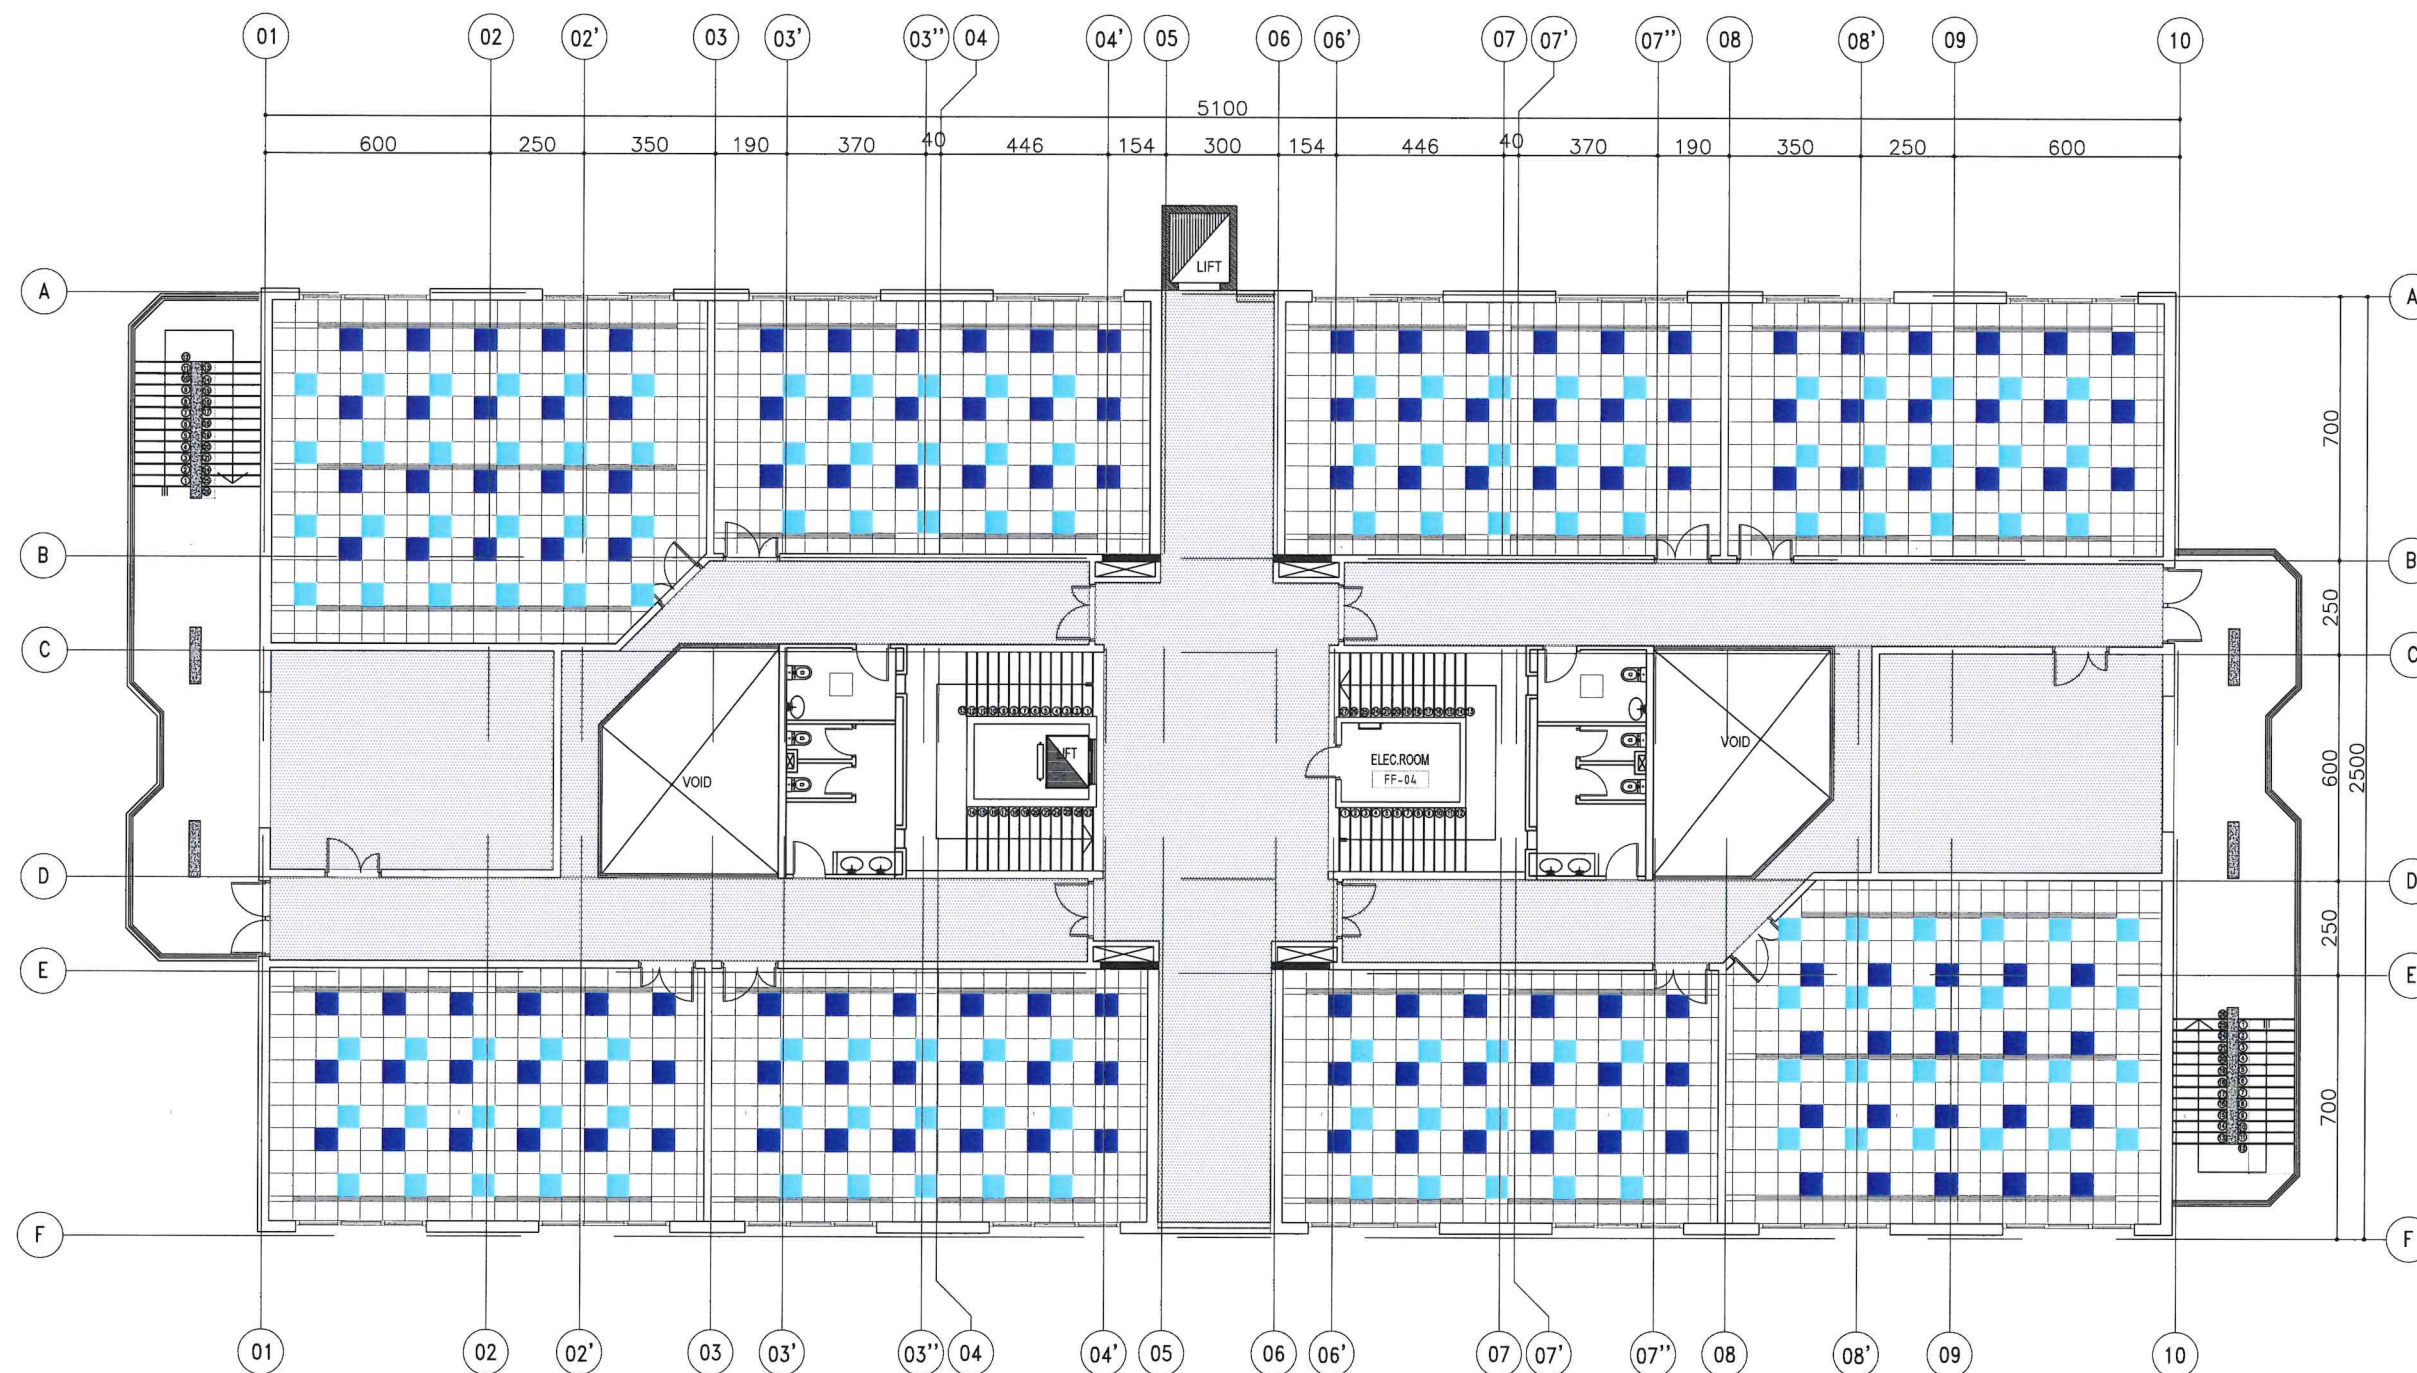

*FELT ACOUSTIC LIGHT BLUE PANEL 600X600MM



*FELT ACOUSTIC DARK BLUE PANEL 600X600MM



*ACOUSTIC TILES 600X600MM

*GYPSUM BOARD CEILING

DATE	REVISIONS	DATE	APPROVED

ABDULLAH AL SALEM UNIVERSITY
FACILITIES MANAGEMENT
& ENGINEERING AFFAIRS


PROJECT TITLE:-

KH-11
Class Rooms (C.O.S)

DRAWING TITLE:-
FIRST FLOOR REFLECTED CEILING

DRAWING NO.

CHECKED BY	SERVICES	CIVIL	ARCH.	SCALE
ENG, ALAA				1:100
APPROVED BY	DRAWN BY	HVAC	ELEC.	DATE
ENG, FATHI	AHMED			MAY.2014

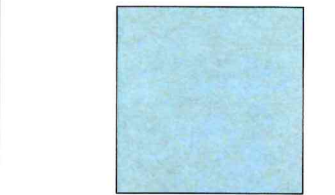

*FELT ACOUSTIC LIGHT BLUE PANEL 600X600MM



*FELT ACOUSTIC DARK BLUE PANEL 600X600MM



*ACOUSTIC TILES 600X600MM

*GYPSUM BOARD CEILING

DATE	REVISIONS	DATE	APPROVED

ABDULLAH AL SALEM UNIVERSITY
FACILITIES MANAGEMENT
& ENGINEERING AFFAIRS

PROJECT TITLE:-
KH-11
Class Rooms (C.O.S)

DRAWING TITLE:-
SECOND FLOOR REFLECTED CEILING

DRAWING NO.

CHECKED BY	SERVICES	CIVIL	ARCH.	SCALE
				1:100

APPROVED BY	DRAWN BY	HVAC	ELEC.	DATE
				MAY.2014